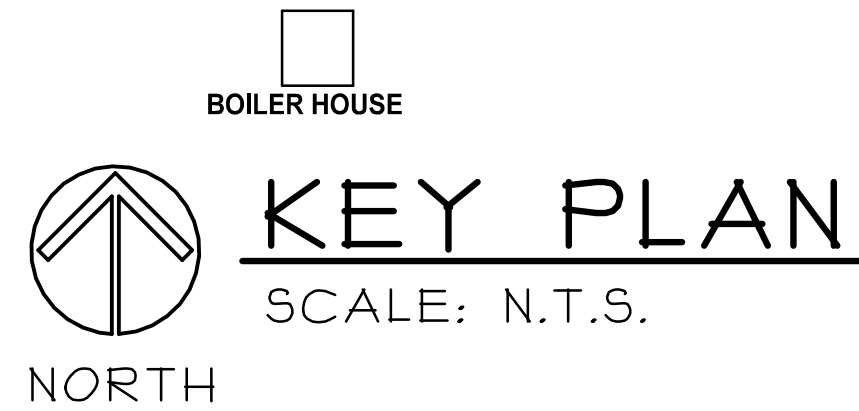
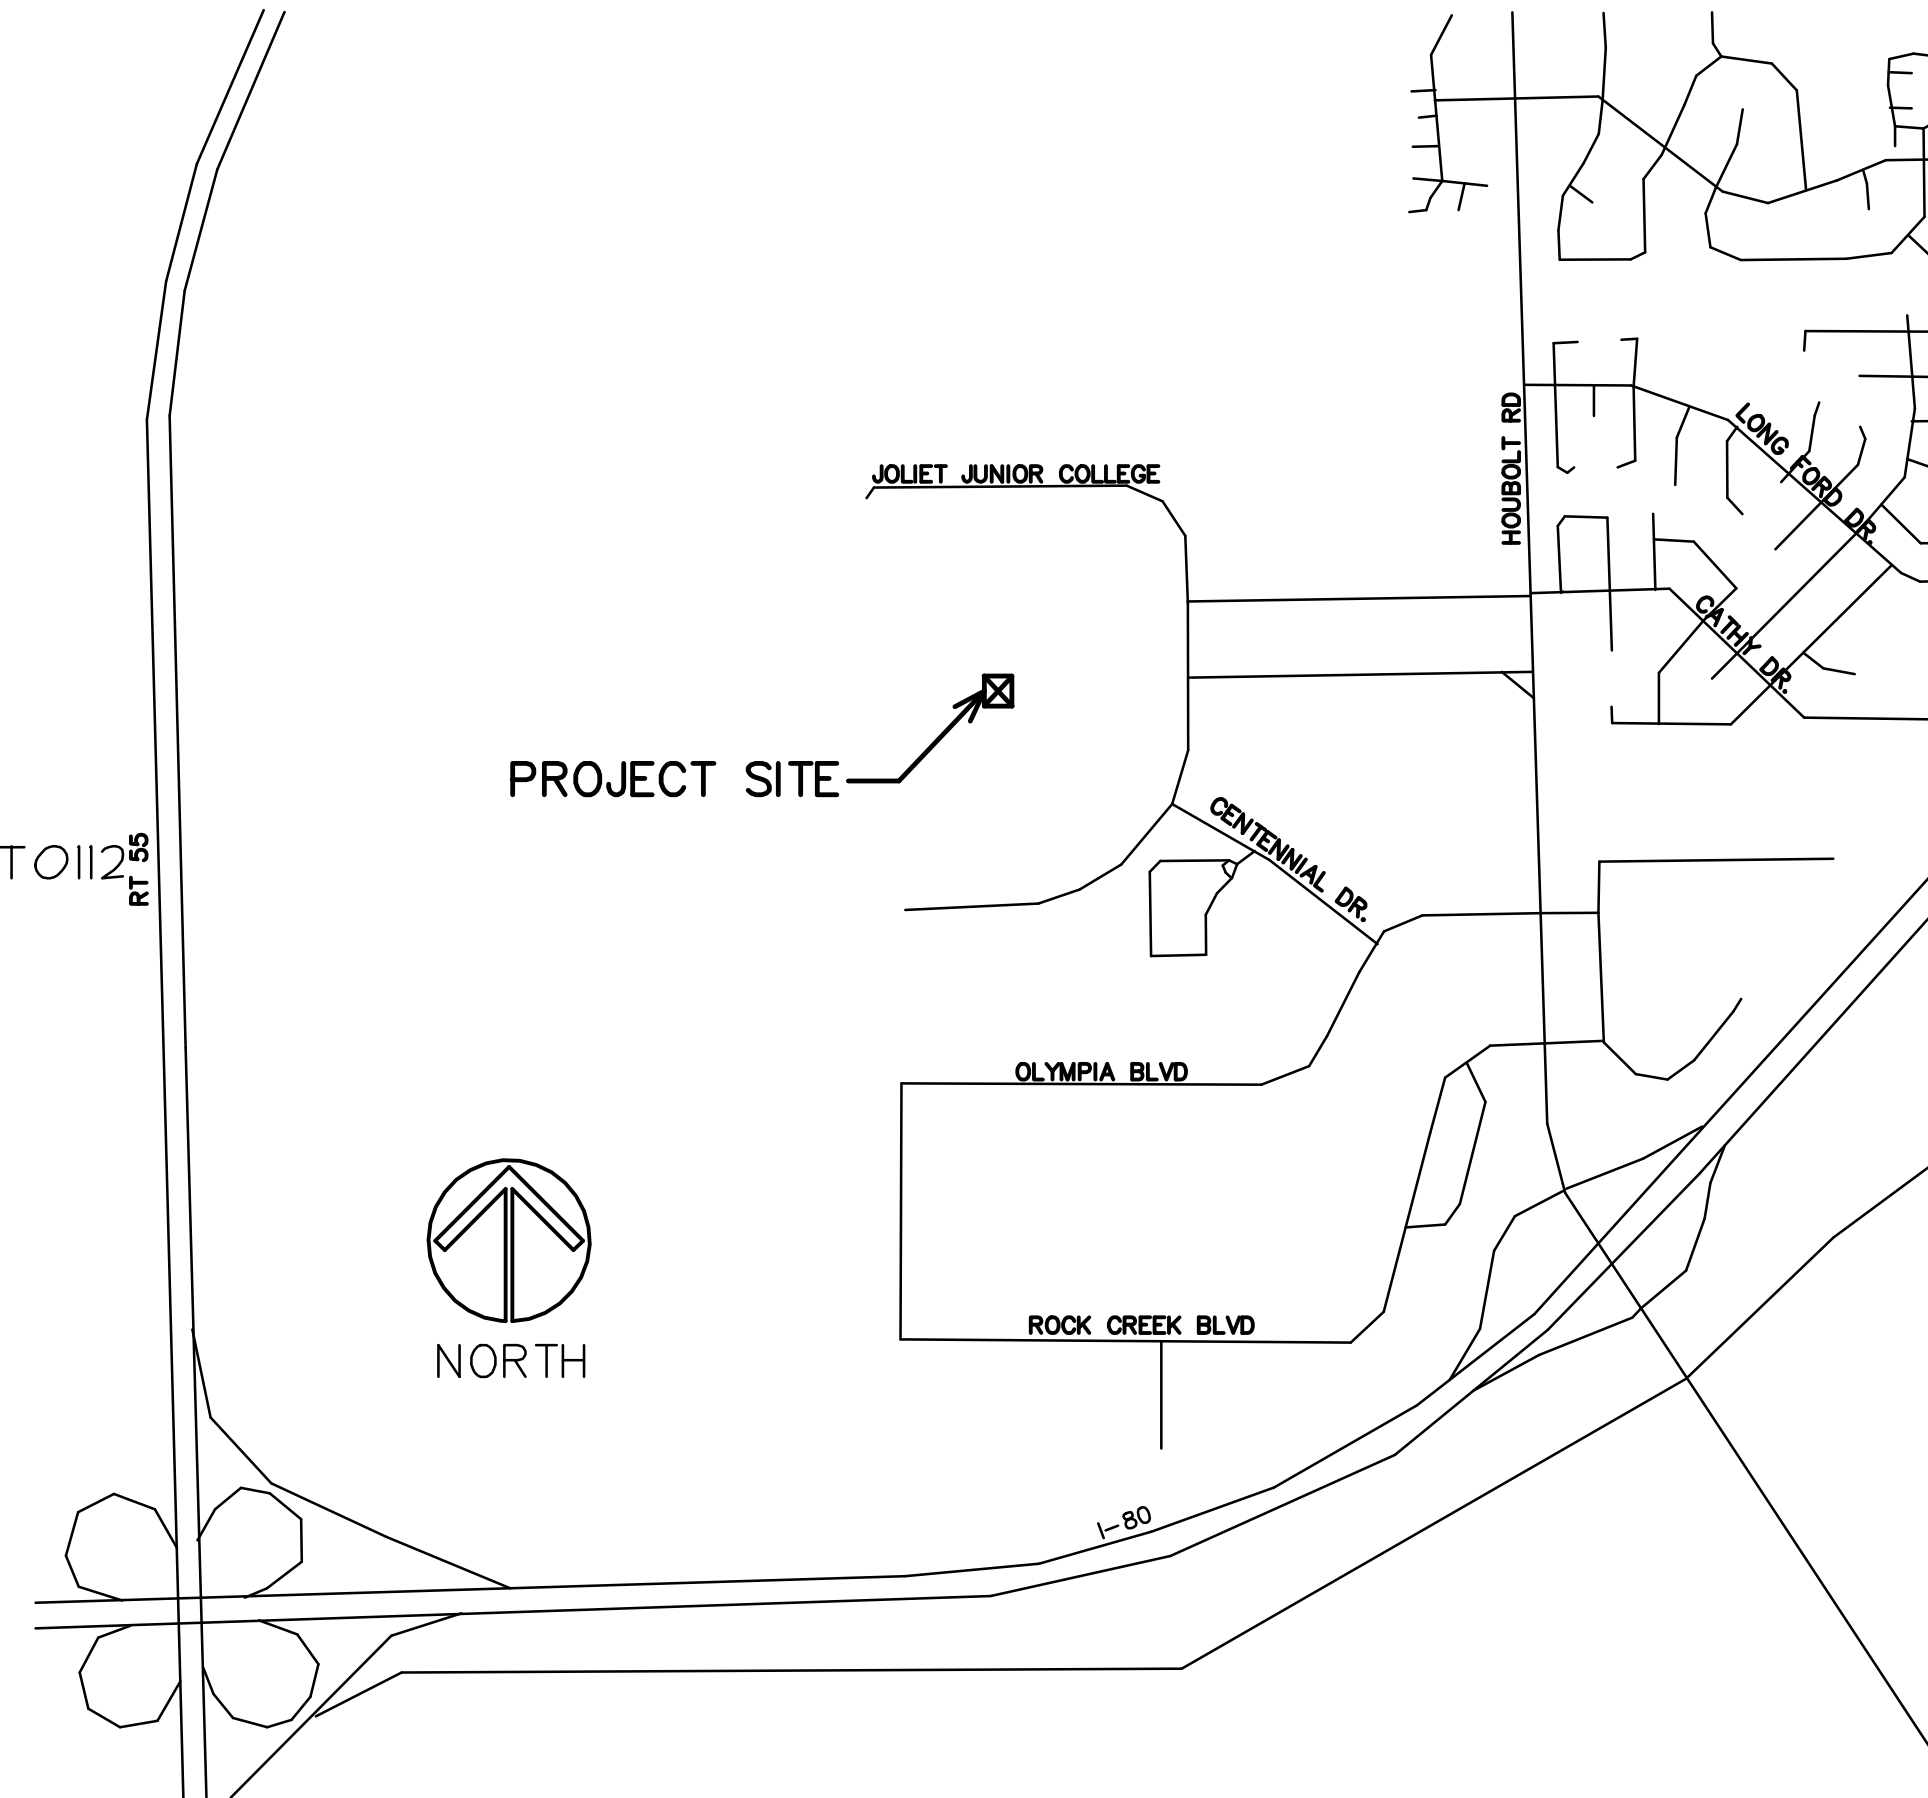


\\192.168.137\CURRENT PROJECTS\JJC - NEW ROBOTICS LAB\DRAWINGS\ARCH\21IL03 T1AEC



LOCATION MAP



INDEX OF SHEETS

- | | |
|----|---|
| T1 | PROJECT TITLE, LOCATION, INDEX OF SHEETS |
| D1 | PARTIAL FIRST LEVEL DEMO FLOOR PLAN |
| D2 | PARTIAL FIRST LEVEL FLOOR DEMO CEILING PLAN |
| A1 | PARTIAL FIRST LEVEL FLOOR PLAN |
| A2 | PARTIAL FIRST LEVEL FLOOR CEILING PLAN |

EEAS LAB EXPANSION

JOLIET JUNIOR COLLEGE
BUILDING T
1215 HOUBOLT ROAD
JOLIET, ILLINOIS

STROMSLAND + DE YOUNG + PRYBYS
ARCHITECTURE GROUP

20620 BURL COURT
JOLIET, IL 60433
PHONE: 815-727-1311
FAX: 815-727-5210

COPYRIGHT 2022 © S D P ARCHITECTURE GROUP, INC.

REGISTRATION

SEAL

stromsland + de young + prybys
ARCHITECTURE GROUP
20620 Burl Court - 102
Joliet, Illinois 60433
www.sdpagroup.com
815-727-1311
L.N.: 184-000437

SET
NUMBER

EEAS LAB EXPANSION
JOLIET JUNIOR COLLEGE- BUILDING T
1215 HOUBOLT ROAD
JOLIET, ILLINOIS

DATE:
1/28/2022
REVISED:

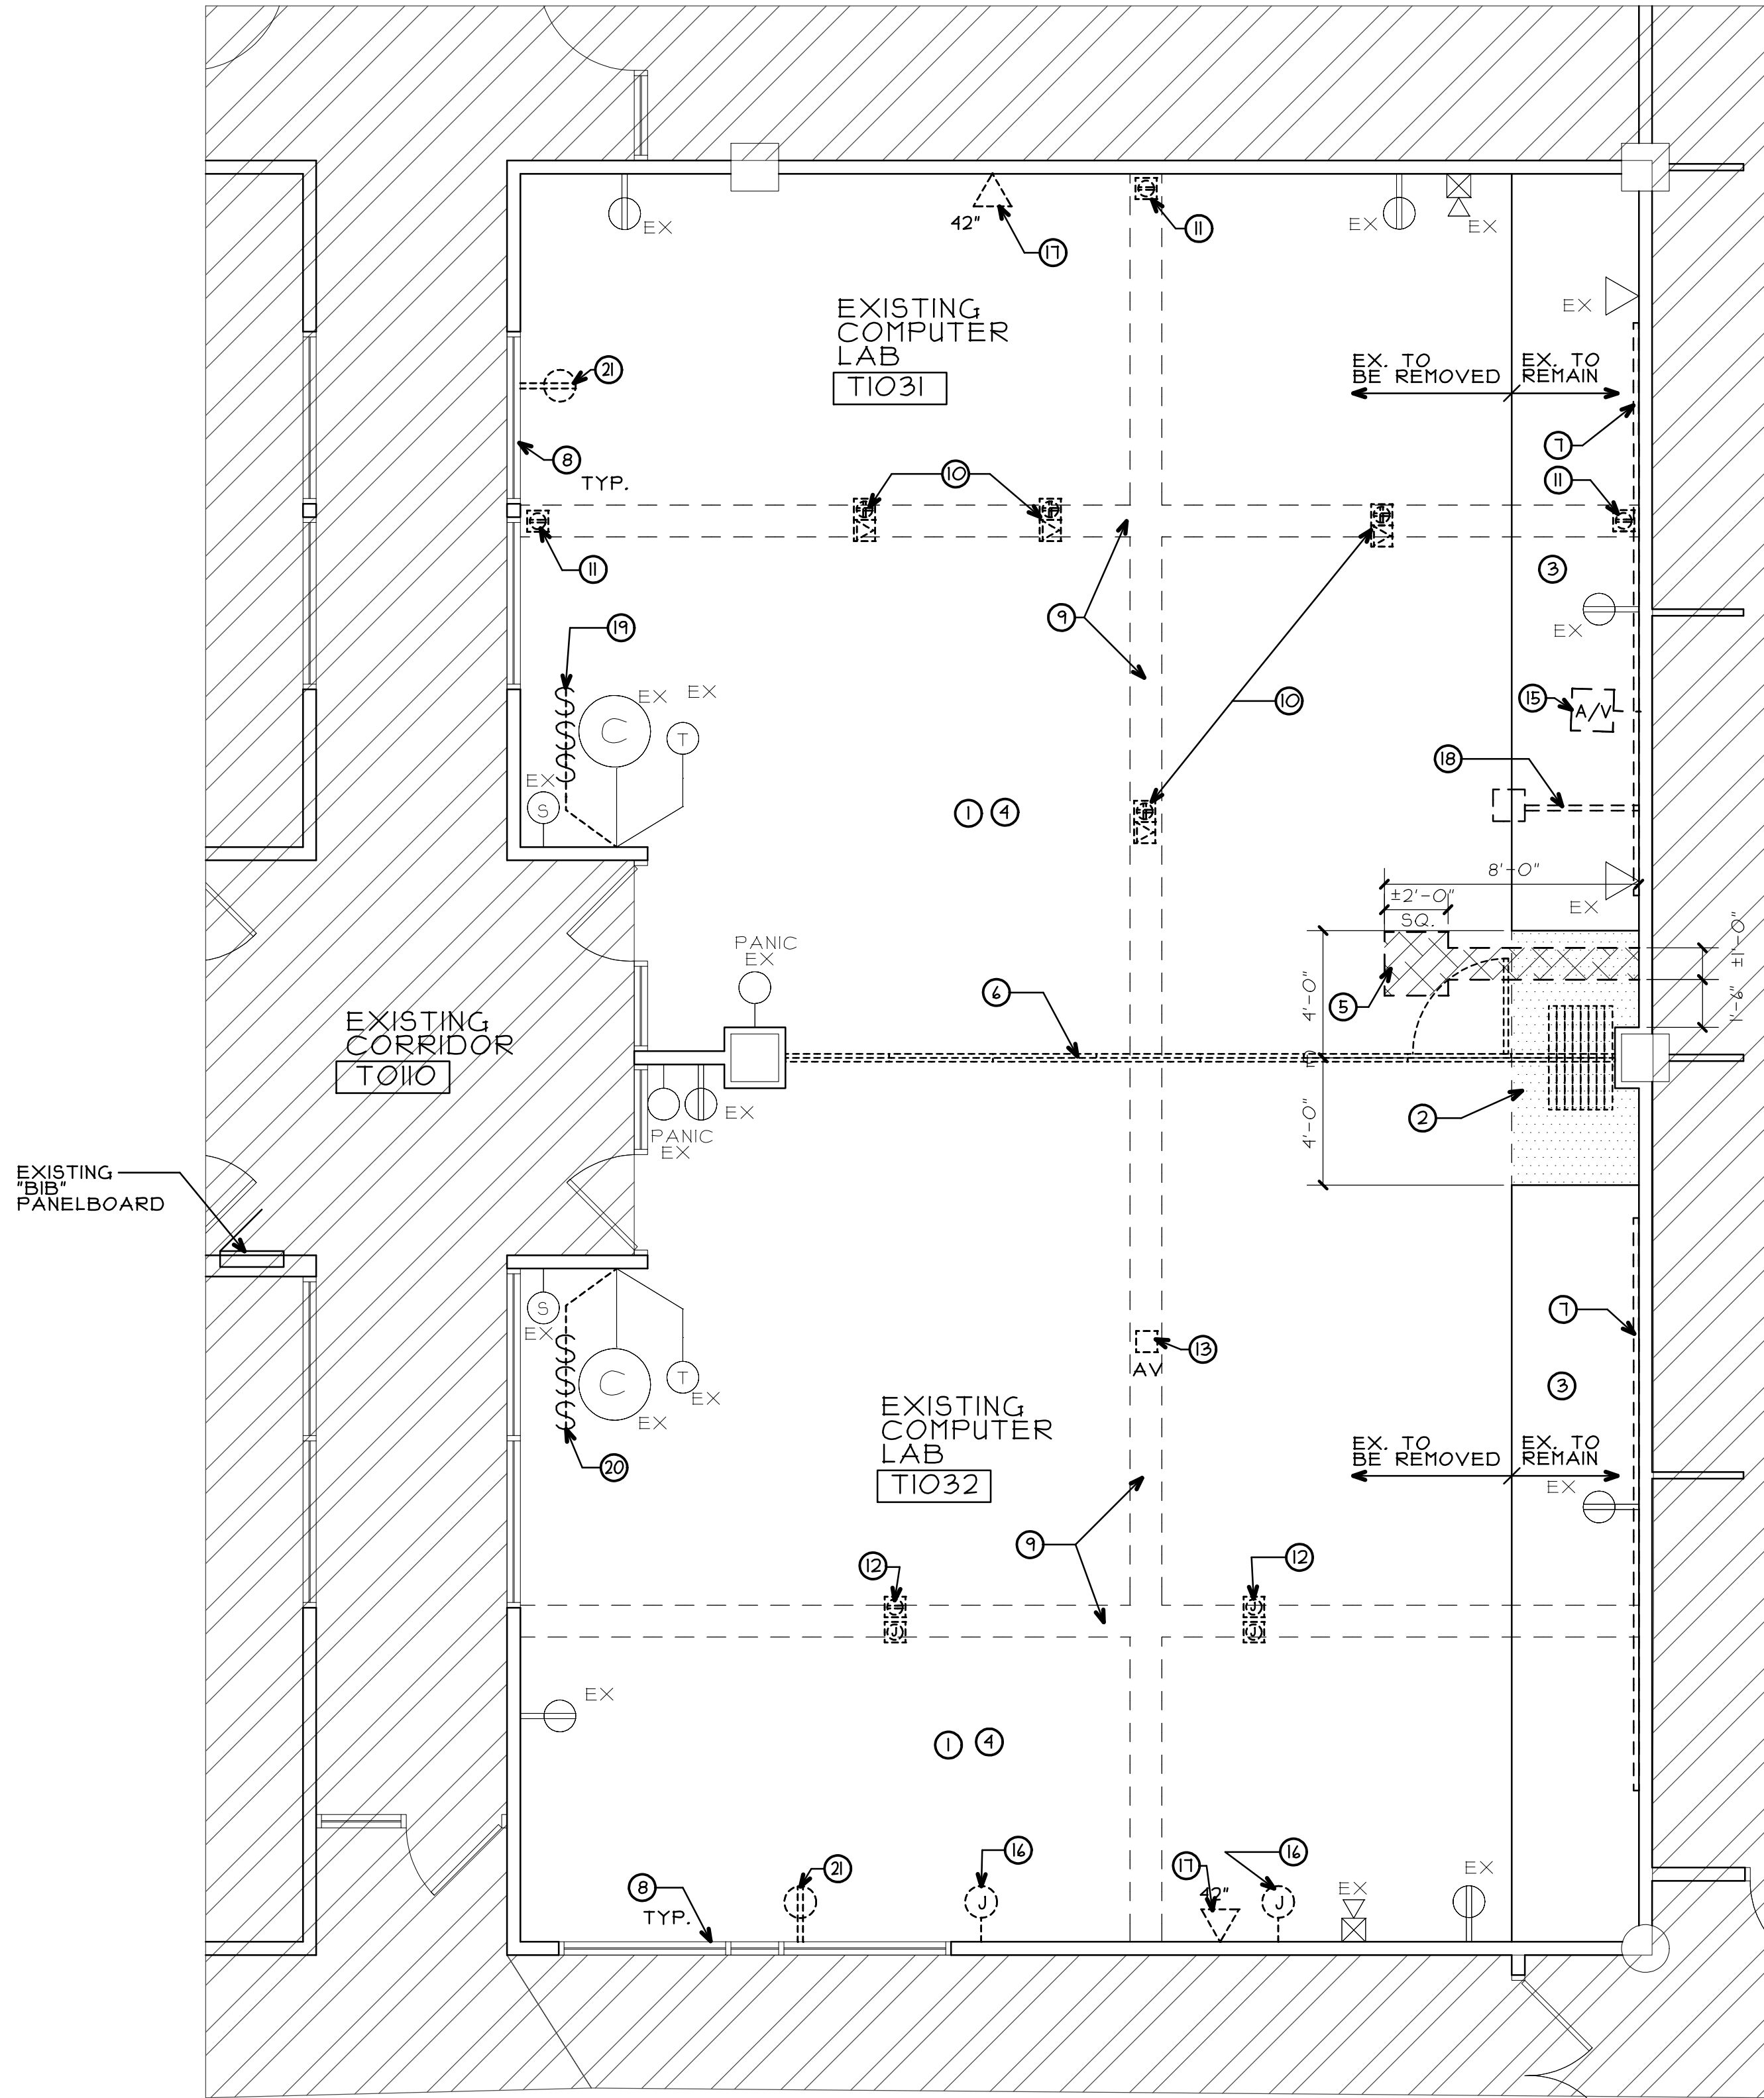
PROJECT NO.
2111-03

SHEET NUMBER

T1

OF 1 SHEETS

\\192.168.1.137\CURRENT PROJECTS\JJC - NEW ROBOTICS LAB\DRAWINGS\ARCH\2111_03 DIA.EC



PARTIAL FIRST FLOOR DEMOLITION FLOOR PLAN

SCALE: 1/4" = 1'-0"

DEMOLITION PLAN LEGEND

- HATCH DENOTES AREAS NOT INCLUDED IN PROJECT SCOPE.
- EXISTING WALLS TO REMAIN (TYPICAL)
- EXISTING DOOR & FRAME TO REMAIN (TYPICAL)
- EX DENOTES EXISTING DEVICE TO REMAIN AND DEVICE TO REMAIN ON EXISTING CIRCUIT

DEMOLITION PLAN GENERAL NOTES

- ALL SALVAGED ITEMS NOT REUSED SHALL BE PLACED IN STORAGE, ON SITE, AT A LOCATION DESIGNATED BY THE OWNER.
- ALL ITEMS REMOVED AND NOT SALVAGED SHALL BE PROPERLY DISPOSED OF OFF SITE BY THE CONTRACTOR.
- PATCH & REPAIR HOLES AND/OR DAMAGED SURFACES CAUSED TO ADJACENT CONSTRUCTION DURING DEMOLITION.
- VERIFY ANY ADDITIONAL DEMOLITION WORK REQUIRED FOR INSTALLATION OF DEVICES/EQUIPMENT.
- EXISTING FURNITURE AND MOVABLE EQUIPMENT TO BE REMOVED BY OWNER'S STAFF. ANYTHING THAT REMAINS CONTRACTOR TO COORDINATE WITH OWNER FOR STORAGE LOCATION. (V.I.F.)
- DEVICES INDICATED WITH AN "EX" ARE TO BE EXISTING TO REMAIN. (V.I.F.)

DEMOLITION PLAN KEY NOTES

- EXISTING V.C.T. FLOORING TO BE REMOVED AND PREP FLOOR FOR NEW FLOOR FINISH.(U.N.O.) (V.I.F.)
- HATCH DESIGNATES PORTION OF BLUE V.C.T. FLOORING TO BE REMOVED AND PREP FLOOR FOR NEW FLOOR FINISH. (V.I.F.)
- EXISTING PORTION OF BLUE V.C.T. FLOORING TO REMAIN. PROVIDE PROTECTION DURING CONSTRUCTION.(V.I.F.)
- ALL EXISTING WALL BASE IN ROOM TO BE REMOVED IN ENTIRETY. (V.I.F.)
- SAW CUT AND REMOVE PORTION OF EXISTING CONCRETE SLAB FOR NEW ELECTRICAL WORK. COORDINATE MOUNT OF SLAB TO BE REMOVED WITH NEW FLOOR BOX AND REQUIRED CONDUIT AND PATCHING DETAIL 1 ON SHEET A1(V.I.F.)
- EXISTING FOLDING WALL PARTITION TO BE COMPLETELY REMOVED. COORDINATE WITH OWNER FOR EXTENT TO BE SALVAGED(V.I.F.)
- EXISTING WHITE BOARD TO BE REMOVED AND SALVAGED TO OWNER. (V.I.F.)
- EXISTING ROLLER SHADES TO REMAIN AND PROVIDE PROTECTION DURING CONSTRUCTION. (V.I.F.)
- EXISTING 1/4'-0" WIDE RECESSED ELECTRICAL TRENCH TO REMAIN. V.C.T. ON EXISTING COVER TO BE REMOVED EXCEPT WHERE SURROUNDING FLOORING TO REMAIN. PATCH EXISTING COVER MATERIALS"(V.I.F.)
- EXISTING FLOOR PEDESTAL RECERTACLES AND DATA PORTS TO BE REMOVED AND POWER WIRING TO BE CAPPED, LABELED AND COILED IN TRENCH FOR POSSIBLE RE-USE IF NOT RE-USED WIRING REMOVED BACK TO JUNCTION BOX TO REMAIN AND BE PROPERLY TERMINATED. DATA CABLING TO BE PULLED TO ABOVE CEILING CAPPED, LABELED AND COILED ABOVE CEILING FOR POSSIBLE RE-USE.(V.I.F.)SALVAGE FLOOR PEDESTAL FOR REUSE.
- EXISTING SURFACE MOUNTED JUNCTION BOX AND DUPLEX OUTLET TO BE REMOVED AND WIRING TO BE CAPPED, LABELED AND COILED IN TRENCH FOR POSSIBLE RE-USE IF NOT RE-USED REMOVE WIRING BACK TO JUNCTION BOX TO REMAIN AND PROPERLY TERMINATE. (V.I.F.)
- EXISTING SURFACE MOUNTED JUNCTION BOX AND FLEXIBLE CONDUIT TO BE REMOVED AND WIRING TO BE CAPPED, LABELED COILED IN TRENCH FOR POSSIBLE RE-USE IF WIRING IS NOT RE-USED REMOVE BACK TO JUNCTION BOX TO REMAIN AND BE PROPERLY TERMINATED(V.I.F.)
- EXISTING FLOOR PEDESTAL AUDIO VISUAL CONNECTION PORT AND BOX TO BE REMOVED AND SIGNAL CABLING TO BE REMOVED BACK TO DESTINATION.(V.I.F.)
- EXISTING AUDIO VISUAL CONNECTION PORT BE BE REMOVED AND SIGNAL CABLING TO BE REMOVED BACK TO DESTINATION. PATCH WALL WITH "LIKE MATERIALS" (V.I.F.)
- EXISTING DATA CABLING TO BE REMOVED TO ABOVE CEILING AND SHOULD BE LABELED AND COILED FOR RE-USE AND COVERPLATE AND JUNCTION BOX TO BE REMOVED. PATCH WALL WITH "LIKE MATERIALS". (V.I.F.)
- EXISTING DATA OUTLET DEVICES TO BE REMOVED AND CABLING TO BE REMOVED TO ABOVE CEILING LABELED AND COILED FOR RE-USE. PATCH WALL WITH "LIKE MATERIALS" (V.I.F.)
- EXISTING WALL MOUNTED PROJECTOR AND BRACKET TO BE COMPLETELY REMOVED. POWER WIRING TO BE REMOVED BACK TO NEAREST JUNCTION BOX TO REMAIN AND BE CAPPED, LABELED WITH PANEL NAME AND CIRCUIT. SIGNAL CABLING TO BE REMOVED BACK TO SOURCE. (V.I.F.)PROJECTOR AND BRACKET TO BE SALVAGED TO OWNER.
- EXISTING SWITCHES TO BE REMOVED AND WIRING TO BE PULLED TO ABOVE CEILING AND CAP AND LABELED AT JUNCTION BOX TO REMAIN. PROVIDE HATCHING BLANK PLATE AT LOCATION OF REMOVED SWITCHES. (V.I.F.)
- EXISTING SWITCHES TO BE REMOVED. EXISTING WIRING TO BE MODIFIED FOR NEW ROOM SWITCHING. SEE SHEET A2 (V.I.F.)
- EXISTING DUPLEX OUTLET DEVICE, AND SINGLE GANG PLASTER RING TO BE REMOVED. EXISTING LOCATION TO REMAIN FOR NEW QUAD OUTLET LOCATION. (V.I.F.)

REGISTRATION

SEAL

stromsland + de young + prybys
ARCHITECTURE GROUP
20620 Burl Court - 102
Joliet, Illinois 60433
815-727-1311
L.N.: 184-00437
www.sdpagroup.com

NUMBER

SET

EEAS LAB EXPANSION
JOLIET JUNIOR COLLEGE- BUILDING T
1215 HOUBOLT ROAD
JOLIET, ILLINOIS

DATE:
1/28/2022
REVISED:

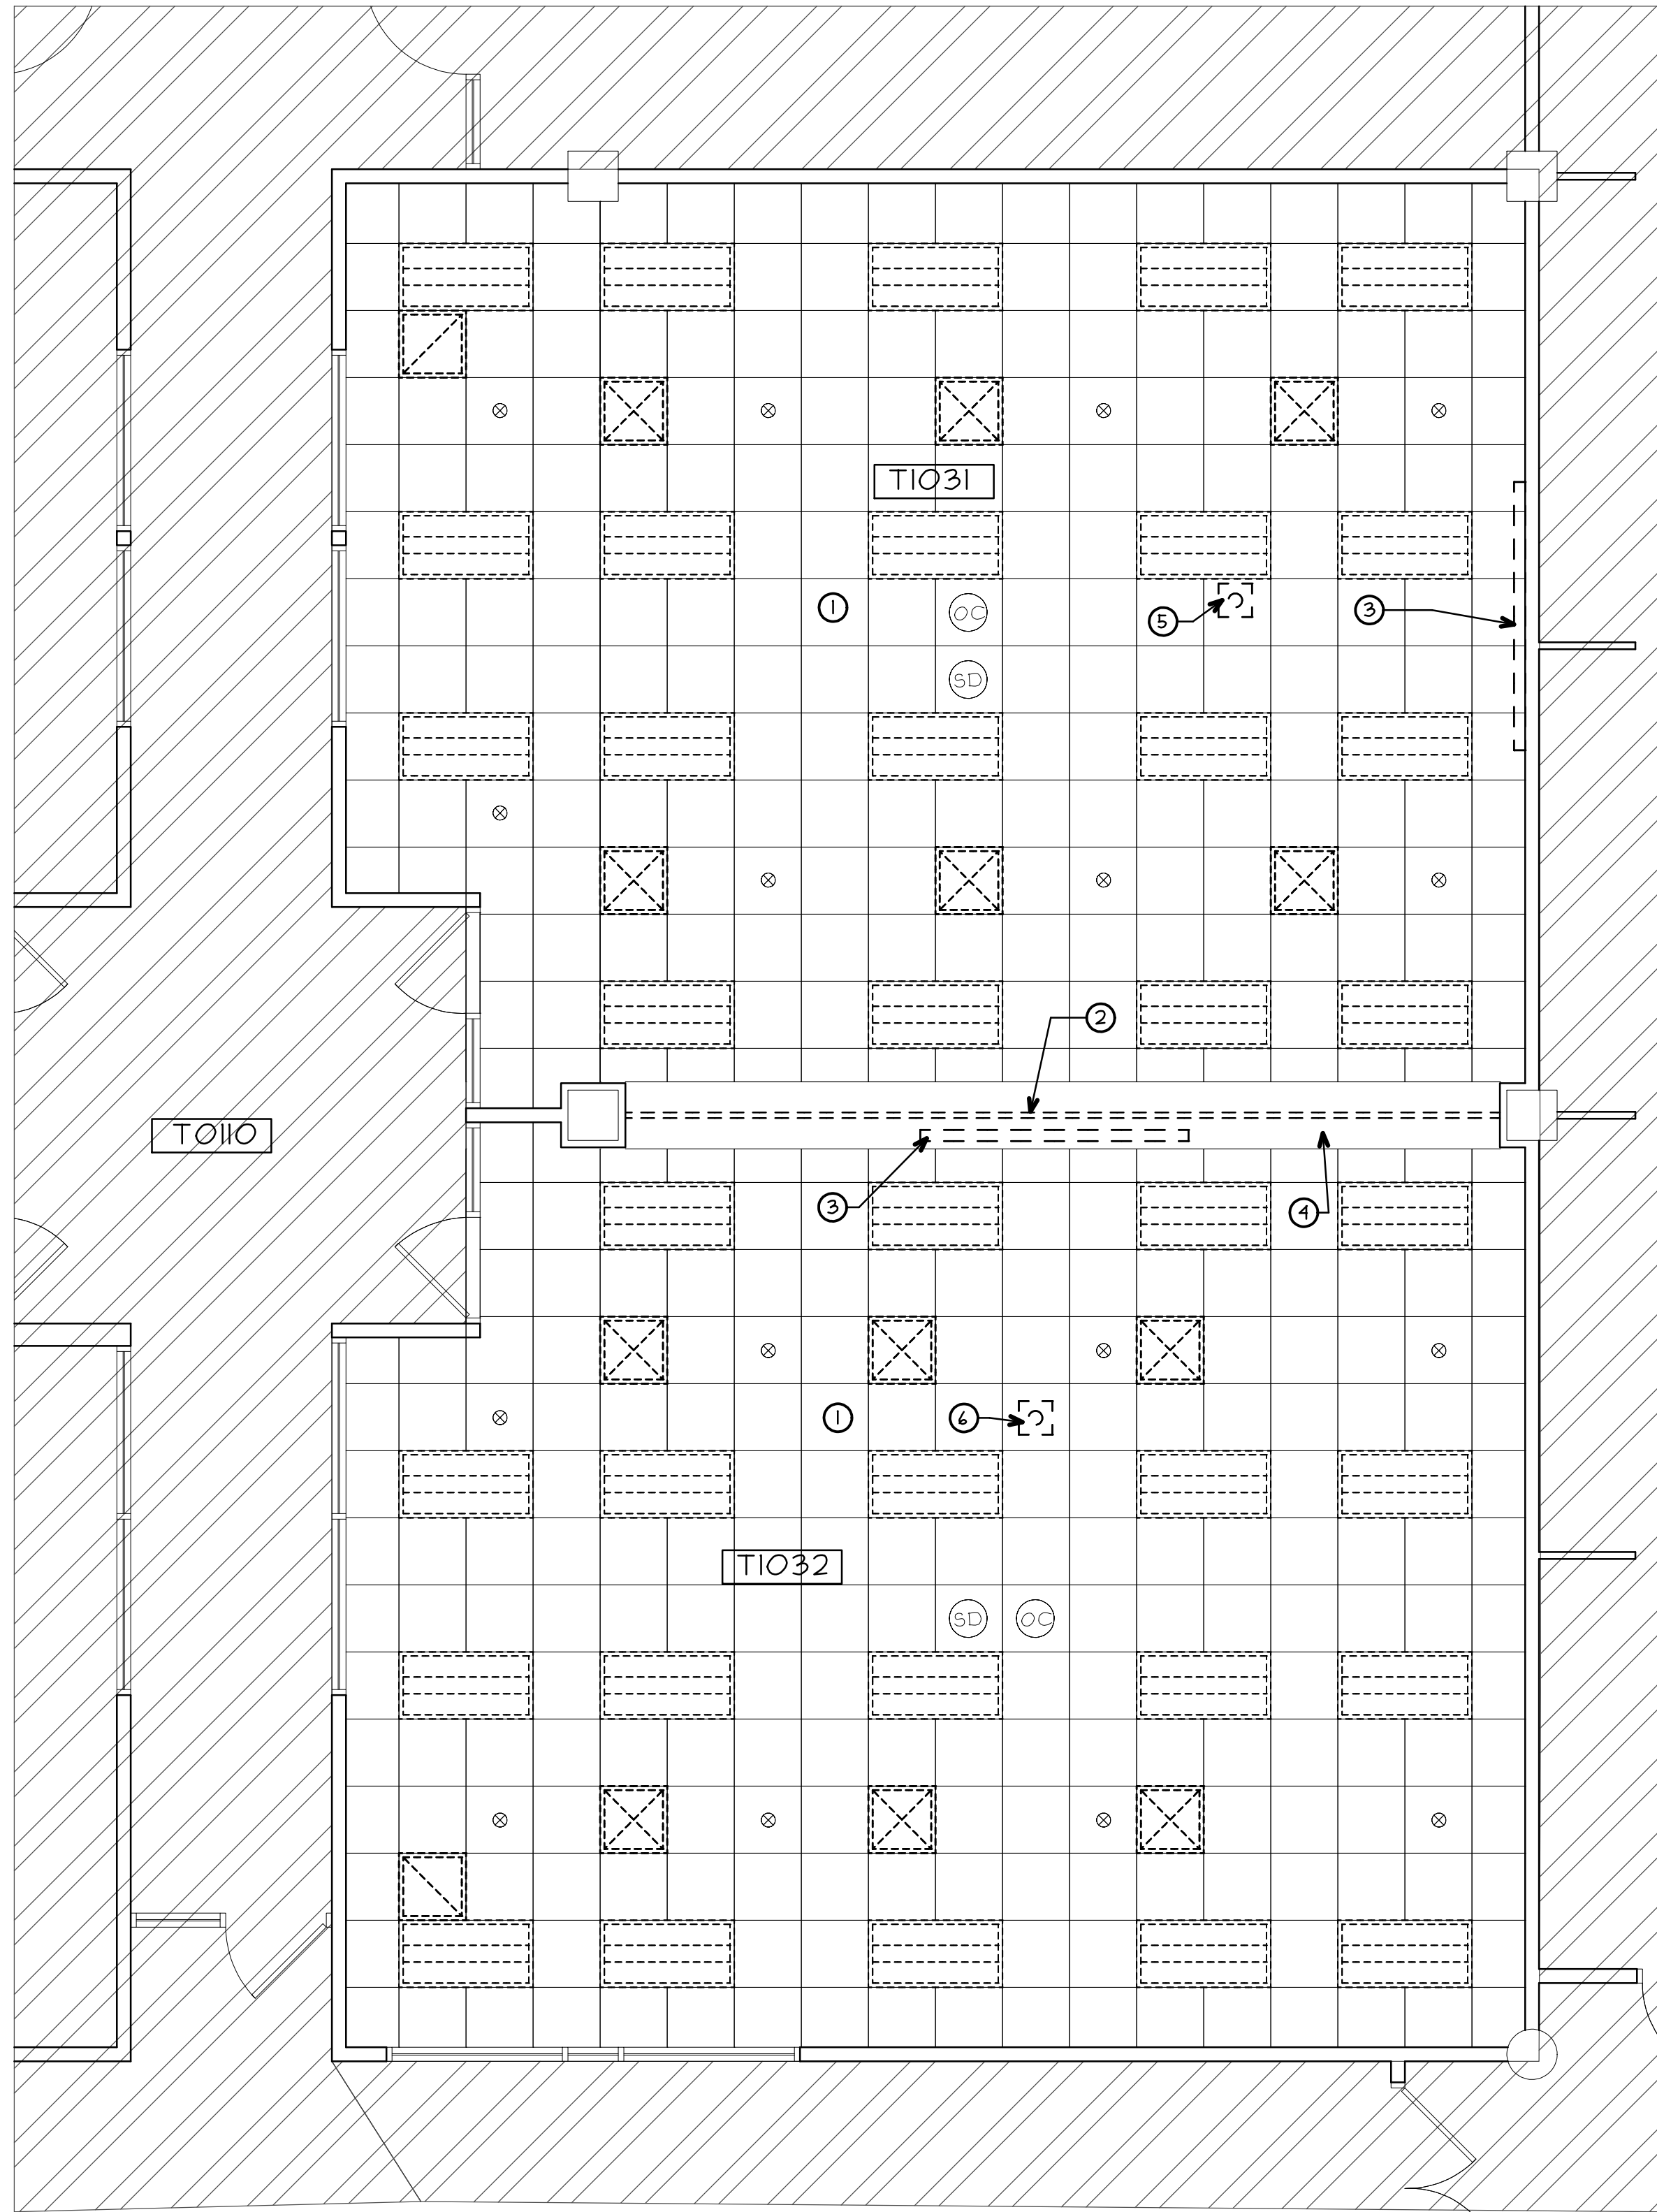
PROJECT NO.
2111-03

SHEET NUMBER

D1





OF 2 SHEETS

\\192.168.137\CURRENT PROJECTS\JJC - NEW ROBOTICS LAB\DRAWINGS\ARCH\2111_03 D2.AEC



 **PARTIAL FIRST FLOOR
DEMO CEILING PLAN**
SCALE: 1/4" = 1'-0"

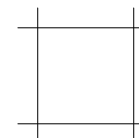   DEMO CEILING PLAN LEGEND

-  HATCH DENOTES AREAS NOT INCLUDED IN PROJECT SCOPE
-  DENOTES EXISTING 2' X 2' SUSPENDED CEILING GRID SYSTEM AND ACOUSTICAL PANELS TO REMAIN (U.N.O.)
-  DENOTES EXISTING LAY-IN LIGHTING FIXTURE TO BE REMOVED. EXISTING WIRING TO BE MODIFIED FOR NEW ROOM SWITCHING. SEE NEW CEILING PLAN.
-  DENOTES EXISTING LAY-IN SUPPLY DIFFUSER TO BE REMOVED. EXISTING DUCTING TO REMAIN FOR REUSE. (V.I.F.)
-  DENOTES EXISTING LAY-IN RETURN REGISTER IN ACOUSTIC CEILING TO BE REMOVED. EXISTING DUCT WORK TO REMAIN FOR REUSE. (V.I.F.)
-  DENOTES EXISTING SPRINKLER HEAD LOCATION IN CEILING/SOFFIT TO REMAIN.
-  DENOTES EXISTING OCCUPANCY SENSOR TO REMAIN. DEVICE TO BE DISCONNECTED AND REINSTALLED FOR CEILING PANEL REPLACEMENT.
-  DENOTES EXISTING SMOKE DETECTOR TO REMAIN. (DEVICE TO BE DISCONNECTED AND REINSTALLED FOR CEILING PANEL REPLACEMENT)
-  DENOTES EXISTING PROJECTOR MOUNT TO BE COMPLETELY REMOVED. SALVAGE FOR POSSIBLE REUSE.(V.I.F.)

DEMO CEILING PLAN GENERAL NOTES

- ALL SALVAGED ITEMS NOT REUSED SHALL BE PLACED IN STORAGE, ON SITE, AT A LOCATION DESIGNATED BY THE OWNER.
- ALL ITEMS REMOVED AND NOT SALVAGED SHALL BE PROPERLY DISPOSED OF OFF SITE BY THE CONTRACTOR.
- PATCH & REPAIR ALL EXISTING GYPSUM BOARD SURFACES TO "LIKE NEW" CONDITION PRIOR TO INSTALLING NEW FINISHES.
- COORDINATE WITH AND ALLOW OWNER'S SEPARATE VENDORS ACCESS TO CEILING INTERSTITIAL SPACES FOR INSTALLATION OF WIRING AND EQUIPMENT PRIOR TO INSTALLING LAY IN CEILING PANELS.

DEMO CEILING PLAN KEY NOTES

- EXISTING CEILING PANELS TO BE REMOVED ENTIRELY IN THIS ROOM. EXISTING CEILING GRID TO REMAIN. (V.I.F.)
- EXISTING FOLDING WALL PARTITION TRACK TO BE REMOVED. (V.I.F.)
- EXISTING DROP DOWN PROJECTION SCREEN AND BRACKETS TO BE COMPLETELY REMOVED. SALVAGE TO OWNER. (V.I.F.)
- EXISTING GYPSUM BOARD SOFFIT TO REMAIN. (V.I.F.)
- EXISTING POWER WIRING AND SIGNAL CABLING TO BE REMOVED AT REMOVED PROJECTOR. POWER WIRING TO BE REMOVED AND PROPERLY TERMINATED BACK AT JUNCTION BOX TO REMAIN AND SIGNAL CABLING TO BE REMOVED BACK TO SOURCE. (V.I.F.)
- EXISTING SIGNAL CABLING TO BE REMOVED BACK TO SOURCE. EXISTING POWER TO REMAIN AND BE MODIFIED AND EXTENDED TO NEW PROJECTOR LOCATION. SEE NEW CEILING PLAN.

REGISTRATION

SEAL

stromsland + de young + prybys
ARCHITECTURE GROUP
20620 Burl Court - 102
Joliet, Illinois 60433
www.sdpagroup.com
L.N.: 184-00437
815-727-1311

NUMBER

SET

EEAS LAB EXPANSION
JOLIET JUNIOR COLLEGE- BUILDING T
1215 HOUBOLT ROAD
JOLIET, ILLINOIS

 
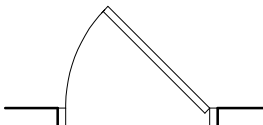
DATE:
1/28/2022
REVISED:

PROJECT NO.
2111-03

SHEET NUMBER

D2

OF 2 SHEETS


-  HATCH DENOTES AREAS NOT INCLUDED IN PROJECT SCOPE.
-  EXISTING WALLS TO REMAIN (TYPICAL)
-  EXISTING DOOR & FRAME TO REMAIN (TYPICAL)
- EX
 DENOTES EXISTING DEVICE TO REMAIN AND DEVICE TO REMAIN ON EXISTING CIRCUIT
-  DENOTES NEW QUAD RECEPTACLE OUTLET IN TWO GANG J BOX WITH TWO GANG PLASTER RING AND COVER PLATE, MOUNTED 18" A.F.F. (U.N.O.) DEVICE COLOR WHITE AND BRUSHED STAINLESS STEEL COVER PLATE TO MATCH FACILITY STANDARD).
-  DENOTES NEW DUPLEX RECEPTACLE OUTLET IN TWO GANG J BOX WITH SINGLE GANG PLASTER RING AND COVER PLATE, MOUNTED 18" A.F.F. (U.N.O.) DEVICE COLOR WHITE AND BRUSHED STAINLESS STEEL COVER PLATE TO MATCH FACILITY STANDARD).
-  DENOTES NEW WHITE DATA OUTLETS, MOUNTED AT 18" A.F.F. (U.N.O.) MIN. 2 PORTS COORDINATE WITH OWNER (TYPICAL) PROVIDE CONDUIT STUBBED TO ABOVE CEILING, RUN PANDUIT (PENUM) RATED CAT6 CABLE (COORDINATE WITH OWNER) BACK TO IDF ROOM (TOI/2IN) REUSE EXISTING PATCH PANEL IN RACK THAT SERVES THIS ROOM AND UPDATE LABELS) (FACILITY STANDARD IS WHITE CABLE)

- A. VERIFY ALL EXISTING DIMENSIONS IN FIELD AND REPORT ALL DISCREPANCIES PRIOR TO NEW CONSTRUCTION.
- B. PATCH & REPAIR ALL EXISTING GYPSUM BOARD SURFACES TO "LIKE NEW" CONDITION PRIOR TO INSTALLING NEW FINISHES.
- C. NEW M-E-P SERVICES IN EXISTING METAL STUD AND GYPSUM BOARD WALLS MAY BE "FISHED DOWN" IF POSSIBLE, OR THE WALL IS TO BE REMOVED AND RE-PAATCHED WITH "LIKE" MATERIALS. COORDINATE WITH M-E-P TRADES.
- D. PROVIDE ALL REQUIRED IN WALL BLOCKING FOR NEW/SALVAGED WALL HUNG EQUIPMENT. COORDINATE WITH OWNER FOR OWNER PROVIDED EQUIPMENT.
- E. FURNITURE AND EQUIPMENT (F.B.O.) SHOWN FOR REFERENCE ONLY UNLESS NOTED OTHERWISE.

- A. EXISTING FLOOR RECEPTACLES ARE SERVED BY PANELBOARD "BC" IN ROOM 1052B AND LIGHTING AND WALL RECEPTACLES ARE FED FROM PANELBOARD "BIB" IN CORRIDOR OUT SIDE PROJECT AREA.
- B. ELECTRICAL CONTRACTOR TO VERIFY EXISTING/NEW CIRCUITS REQUIRED (CIRCUIT NUMBERS SHOWN ARE ARBITRARY) VERIFY WITH ELECTRICAL MEMBERS WITH 1052B AND 1052C AFTER DEMOLITION FROM TWO PANEL BOARDS SERVING THIS ROOM AND UPDATE PANEL DIRECTORIES. EXISTING CIRCUITS THAT ARE DEMOED AND NOT REUSED SHALL BE LISTED AS SPARE.
- C. ALL EQUIPMENT AND MATERIALS SHALL BE U.L. LABELED.
- D. ALL EQUIPMENT SHALL BE GROUNDED WITH EQUIPMENT GROUNDING CONDUCTORS BACK TO PANEL BOARD.
- E. ALL EQUIPMENT IS TO BE NEW, FURNISHED, INSTALLED AND WIRED BY E.C. UNLESS NOTED OTHERWISE.
- F. ALL WIRING SHALL BE IN CONDUIT APPROVED RACEWAYS, NO EXPOSED WIRING WITH BE APPROVED WITHOUT LOCAL CODE APPROVAL AND PERMITTING.
- G. INSTALLATION SHALL MEET ALL JOLiet ELECTRICAL CODES AND E.C. IS RESPONSIBLE TO PAY ALL FEES, TAXES AND PERMITS AS REQUIRED.

(NEW ROOM FINISHES TO MEET FACILITY STANDARDS)
FLOOR: VCT #51903 BLUE/GRAY IMPERIAL TEXTURE STANDARD EXCELON
BY ARMSTRONG.
BASE: RUBBER COVE BASE #40 BLACK BY JOHNSONITE.
WALLS/SOFFIT: PAINT- SW7004 SNOWBOUND BY SHERWIN WILLIAMS.
ACCENT PAINT: AC-1 #840 KENSINGTON BLUE BY BENJAMIN MOORE.
CEILING: EXISTING GRID TO REMAIN.
CEILING PANELS ARE 2X2 ASTRO CLIMA PLUS BY USG

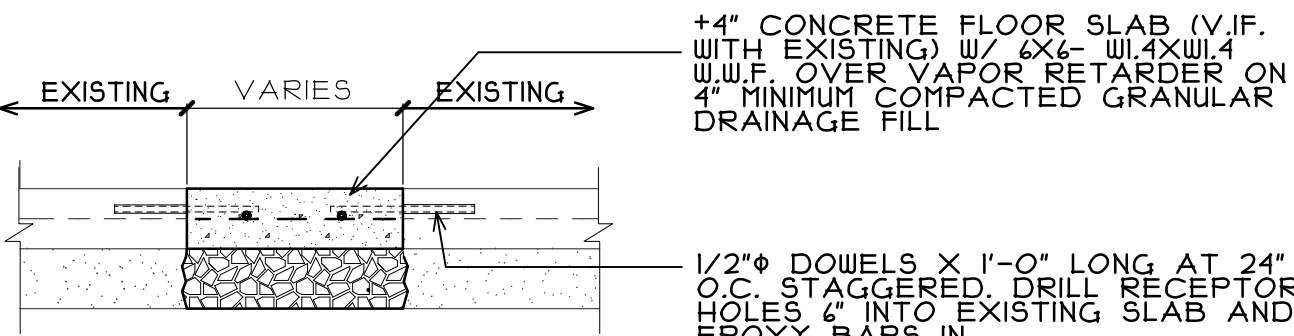
- AT LOCATION OF REMOVED FOLDING PARTITION (SEE DEMOLITION PLANS) EXISTING WALLS TO REMAIN ARE TO BE PATCHED WITH "LIKE" MATERIALS MATCHING ADJOINING (SIZE, THICKNESS, ETC.) V.I.F.
- PROVIDE PAINTED ACCENT WALL (AC-1).
- PROVIDE 4'-0" HIGH FULL WALL WIDTH SURFACE APPLIED WHITE BOARD. FLEX WRITE SURFACE BY "POST-IT". MOUNT TOP AT 7'-0" AFF.
- PROVIDE 8'-0" WIDE SURFACE MOUNTED ALUMINUM MARKER TRAY WITH ANGLED CORNERS, OPTIMA-GR-ATLASRC-08 BY ATLASRAY OR APPROVED EQUAL MOUNT AT CENTERLINE OF AND UNDER BOTTOM EDGE OF SURFACE APPLIED WHITE BOARD.
- PROVIDE NEW VCT FLOORING AND VINYL BASE ON ALL WALLS. (UNDER NEW FLOORING TO CONTINUE ON ELECTRICAL TRENCH COVER).
- PORTION OF EXISTING BLUE VCT FLOORING TO REMAIN. (V.I.F.)
- PATCH EXISTING CONCRETE AT LOCATION OF NEW UNDER SLAB. (V.I.F.) AND LOW VOLTAGE CONDUIT. SEE DETAIL 1 ON SHEET "A1".
- RE-INSTALL SALVAGED FLOOR SERVICE PEDESTALS WITH TWO DUPLX RECEPTACLES AND TWO DATA JACKS EACH SIDE OF PEDESTAL. CONNECT TO NEW CIRCUIT AND RUN CAT6 DATA CABLE IN EXISTING TRENCH BACK TO IDF ROOM 1012 (COORDINATE WITH OWNER)
- INSTALL NEW MATCHING FLOOR SERVICE PEDESTAL (LEGRAND MP8 DUPLX) WITH REQUIRED PLATES AND ACCESSORIES. (V.I.F.) WITH TWO DUPLX RECEPTACLES AND TWO DATA JACKS EACH SIDE OF PEDESTAL. POWER TO CONNECT TO NEW CIRCUIT AND RUN CAT6 DATA CABLE IN EXISTING TRENCH BACK TO IDF ROOM 1012 (COORDINATE WITH OWNER)
- PROVIDE NEW COMBINATION POWER AND DATA FLOOR BOX (LEGRAND BRFB4-CI-NA WITH AFFCTUAL COVER WITH DEVICE PLATES AND ACCESSORIES) AND 1" CONDUIT FOR POWER AND 1 1/2" CONDUIT FOR DATA TO WALL STUB UP TO ABOVE ACCESSIBLE CEILING.
- PROVIDE (2) NEW DUPLX OUTLETS, AND COVERPLATES IN NEW FLOOR BOX AND CONNECT TO NEW CIRCUIT(V.I.F.)
- PROVIDE (2)NEW DATA OUTLETS, AND COVERPLATE IN NEW FLOOR BOX AND PROVIDE CAT6 CABLE BACK TO IDF ROOM 1012(V.I.F.)
- PROVIDE NEW DATA OUTLET, AND COVERPLATE IN NEW FLOOR BOX AND PROVIDE CAT6 CABLE UP TO NEW PROJECTOR LOCATION(V.I.F.)
- PROVIDE (1) NEW OUTLET AND NEW TWO GANG PLASTER RING AT EXISTING BOX LOCATION AND RECONNECT TO EXISTING CIRCUIT. (V.I.F.)
- NEW METAL WORK STATIONS TO BE PROVIDED BY OWNER AND ASSEMBLED AND INSTALLED BY CONTRACTOR. (COORDINATE WITH OWNER FOR FINAL SELECTED WORKSTATIONS)
- NEW TEACHER'S WORKSTATION TO BE PROVIDED BY OWNER AND ASSEMBLED AND INSTALLED BY CONTRACTOR. (COORDINATE WITH OWNER FOR FINAL SELECTED WORKSTATIONS)



AI NO SCALE






NOTE:
GENERAL CONTRACTOR TO PROVIDE A \$5,000 ALLOWANCE IN HIS/HER BID FOR UNFORESEEN/WHISCELLANEOUS CONDITIONS. WHEN FIGURING THIS BID, THE CONTRACTOR IS TO INCLUDE ALL NECESSARY OVERHEAD AND PROFIT TO CARRY THIS DOLLAR VOLUME. THIS ALLOWANCE IS NOT TO BE USED FOR CONTRACTS BEYOND AND ONLY AUTHORIZED TO CHARGE AGAINST THIS ALLOWANCE WHEN DIRECTED AND APPROVED BY JOLIET JUNIOR COLLEGE. THE CONTRACTOR WILL BE ALLOWED TO INCREASE FOR DIRECT MATERIAL AND R/L LABOR COSTS ONLY.

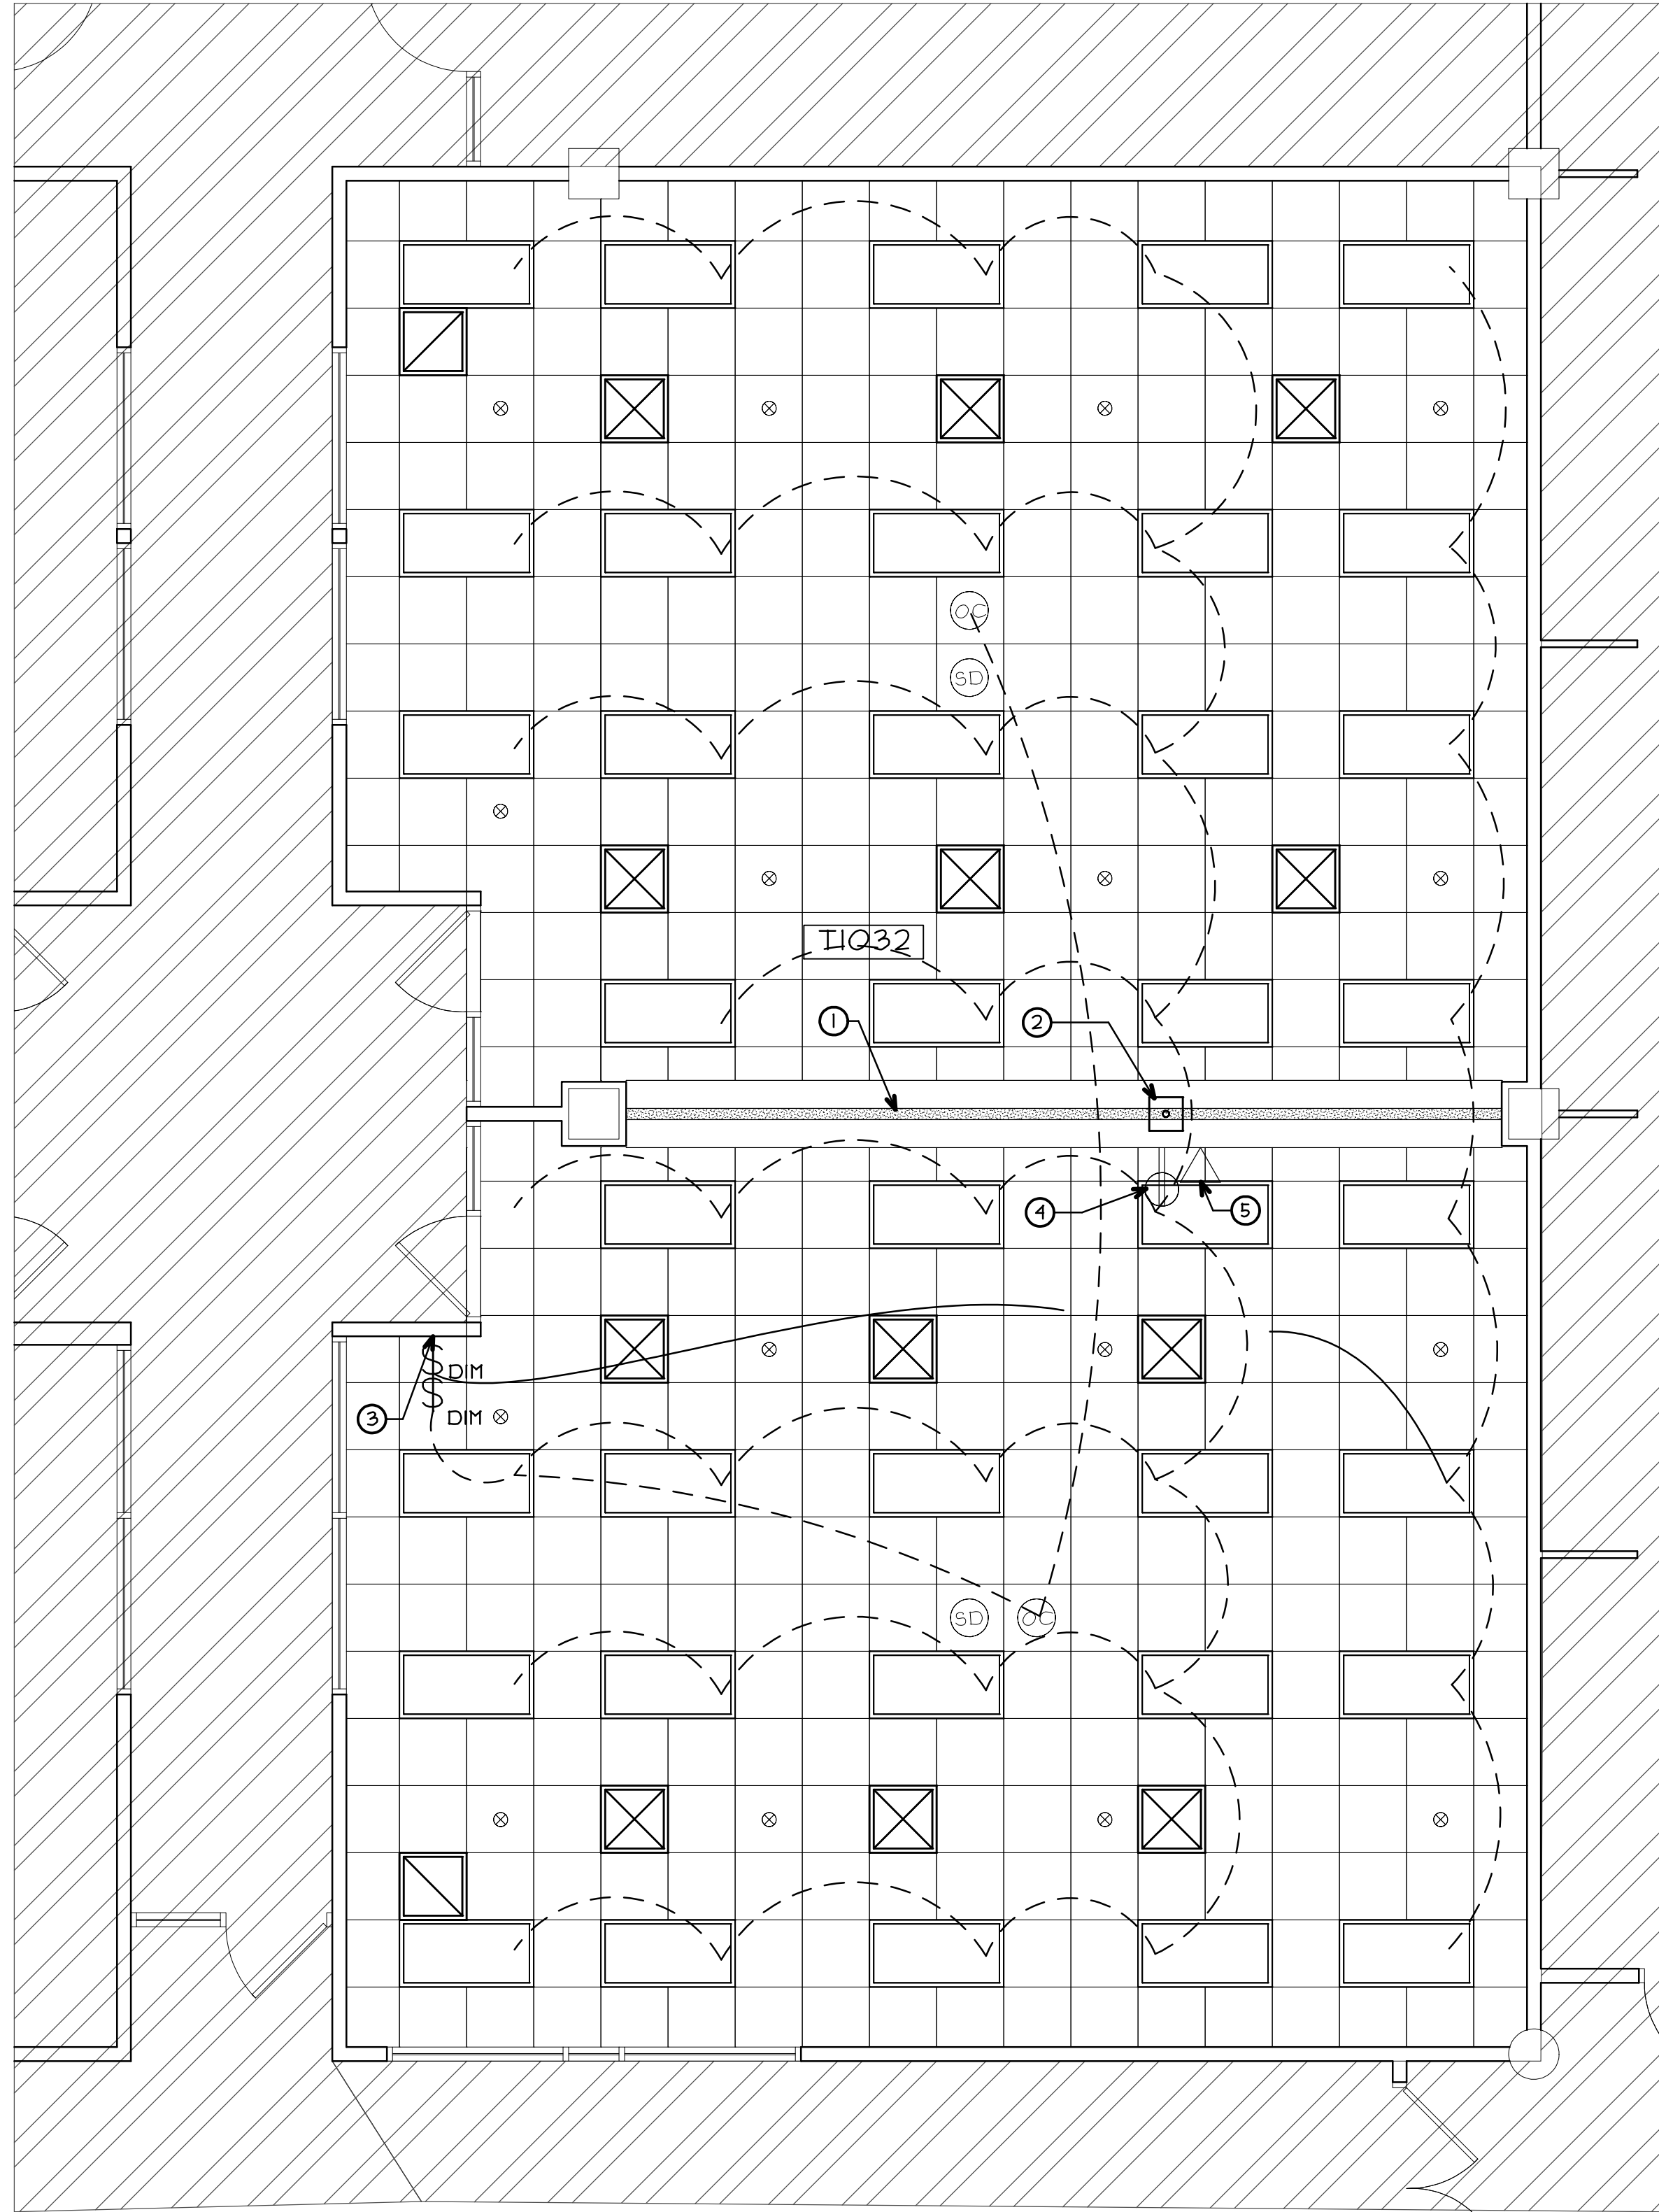\\192.168.1.137\CURRENT PROJECTS\JJC - NEW ROBOTICS LAB\DRAWINGS\ARCH\2111_03_A2.AEC



 **PARTIAL FIRST FLOOR
CEILING PLAN**
SCALE: 1/4" = 1'-0"

 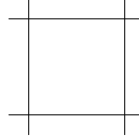   REFLECTED CEILING PLAN LEGEND

-  HATCH DENOTES AREAS NOT INCLUDED IN PROJECT SCOPE
-  DENOTES EXISTING 2' X 2' SUSPENDED CEILING GRID SYSTEM TO REMAIN WITH NEW ACOUSTICAL PANELS. SEE ROOM FINISH SCHEDULE.
-  DENOTES NEW LED LAY-IN LIGHTING FIXTURE IN ACOUSTIC CEILING.
(EPANL2X4-4000LM-80CRI-40K-ZT-MVOLT BY LITHONIA LIGHTING TO MATCH FACILITY STANDARD) CONNECT TO NEW ROOM SWITCHING.
-  DENOTES NEW LAY-IN SUPPLY DIFFUSER IN ACOUSTIC CEILING (NAILOR PLAQUE FACE "UNI" TO MATCH FACILITY STANDARD) CONNECT TO EXISTING SUPPLY DUCT WORK AND SEE MECHANICAL NOTES
-  DENOTES NEW LAY-IN RETURN REGISTER IN ACOUSTIC CEILING (NAILOR LOUVERED FACE "44H" TO MATCH FACILITY STANDARD) CONNECT TO EXISTING RETURN DUCTWORK AND SEE MECHANICAL NOTES
-  DENOTES EXISTING SPRINKLER HEAD LOCATION IN CEILING/SOFFIT TO REMAIN.
-  DENOTES EXISTING OCCUPANCY SENSOR RE-INSTALLED IN CENTER OF NEW CEILING PANEL. MODIFY WIRING AS REQUIRED FOR NEW ROOM SWITCHING. (V.I.F.)
-  DENOTES EXISTING SMOKE DETECTOR RE-INSTALLED IN CENTER OF NEW CEILING PANEL
-  DENOTES NEW DIMMER SWITCH (LEVITON IP110-LF IS FACILITY STANDARD) BRUSHED STAINLESS STEEL COVERPLATE.

CEILING PLAN GENERAL NOTES

- PATCH & REPAIR ALL EXISTING GYPSUM BOARD SURFACES TO "LIKE NEW" CONDITION PRIOR TO INSTALLING NEW FINISHES.
- CEILING GRID AND LAY-IN PANEL TYPES ARE EXISTING TO REMAIN. (U.N.O.)
- COORDINATE WITH AND ALLOW OWNER'S SEPARATE VENDORS ACCESS TO CEILING INTERSTITIAL SPACES FOR INSTALLATION OF WIRING AND EQUIPMENT PRIOR TO INSTALLING LAY-IN CEILING PANELS.
- EXISTING DAMAGED ACOUSTIC CEILING PANELS SHALL BE CLEANED OR REPLACED WITH NEW MATCHING PANELS FROM OWNERS ATTIC STOCK (V.I.F.).
- ALL GYPSUM BOARD SOFFITS, HEADERS, ETC. WITHIN THE WORK AREA ARE TO RECEIVE A NEW PAINT FINISH.

MECHANICAL GENERAL NOTES

- EXISTING MECHANICAL SYSTEMS TO BE REUSED. VERIFY OPERATION, CALIBRATE CONTROLS, AND SUBMIT DEFICIENCY REPORT TO OWNER AND AWAIT FURTHER DIRECTION. PROVIDE NEBB CERTIFIED TEST AND BALANCE TO DOCUMENT SUPPLY AND RETURN AIR FLOWS FOR OWNERS RECORD'S.

CEILING PLAN KEY NOTES

- PATCH EXISTING GYPSUM BOARD SOFFIT AT LOCATION OF REMOVED FOLDING PARTITION TRACK WITH "LIKE MATERIALS".
- LOCATION FOR NEW PROJECTOR MOUNT FURNISHED BY OWNER INSTALLED BY CONTRACTOR. MOUNT TO BOTTOM OF STEEL BEAM ABOVE. (COORDINATE EXACT LOCATION WITH OWNERS STAFF)
- PROVIDE SURFACE MOUNTED BOX ON EXISTING CLOCK AND SWITCH UNIT. FOR NEW ROOM SWITCHING. COORDINATE WITH OWNER.
- PROVIDE DUPLEX RECEPTACLE AND SURFACE MOUNTED JUNCTION BOX ABOVE CEILING ON SIDE OF SOFFIT WALL ABOVE AT LOCATION OF NEW PROJECTOR. EXTEND EXISTING WIRING ABOVE CEILING FROM REMOVED PROJECTOR LOCATION TO NEW LOCATION AND RECONNECT. (PROVIDE WHITE PLASTIC FINISHED GROMMET IN CEILING PANEL FOR PROJECTOR WIRING ACCESS)
- PROVIDE NEW DATA OUTLET LOCATION ABOVE CEILING AT NEW PROJECTOR LOCATION WITH TWO PORTS RUN ONE BACK TO TEACHERS DESK LOCATION AND OTHER TO RUN BACK TO IDF ROOM 10112. (V.I.F.)

REGISTRATION

SEAL

stromsland + de young + prybys
ARCHITECTURE GROUP
815-727-1311
L. N. : 184-00437
www.sdpagroup.com
20620 Burl Court - 102
Joliet, Illinois 60438

NUMBER

SET

EEAS LAB EXPANSION
JOLIET JUNIOR COLLEGE- BUILDING T
1215 HOBBS ROAD
JOLIET, ILLINOIS

DATE:
1/28/2022
REVISED:

PROJECT NO.
2111-03

SHEET NUMBER

A2

OF 2 SHEETS