


\\192.168.137\CURRENT PROJECTS\JJC ROMEVILLE CAMPUS- CISCO LAB RENOVATIONS\DRAWINGS\ARCH\T1AEC

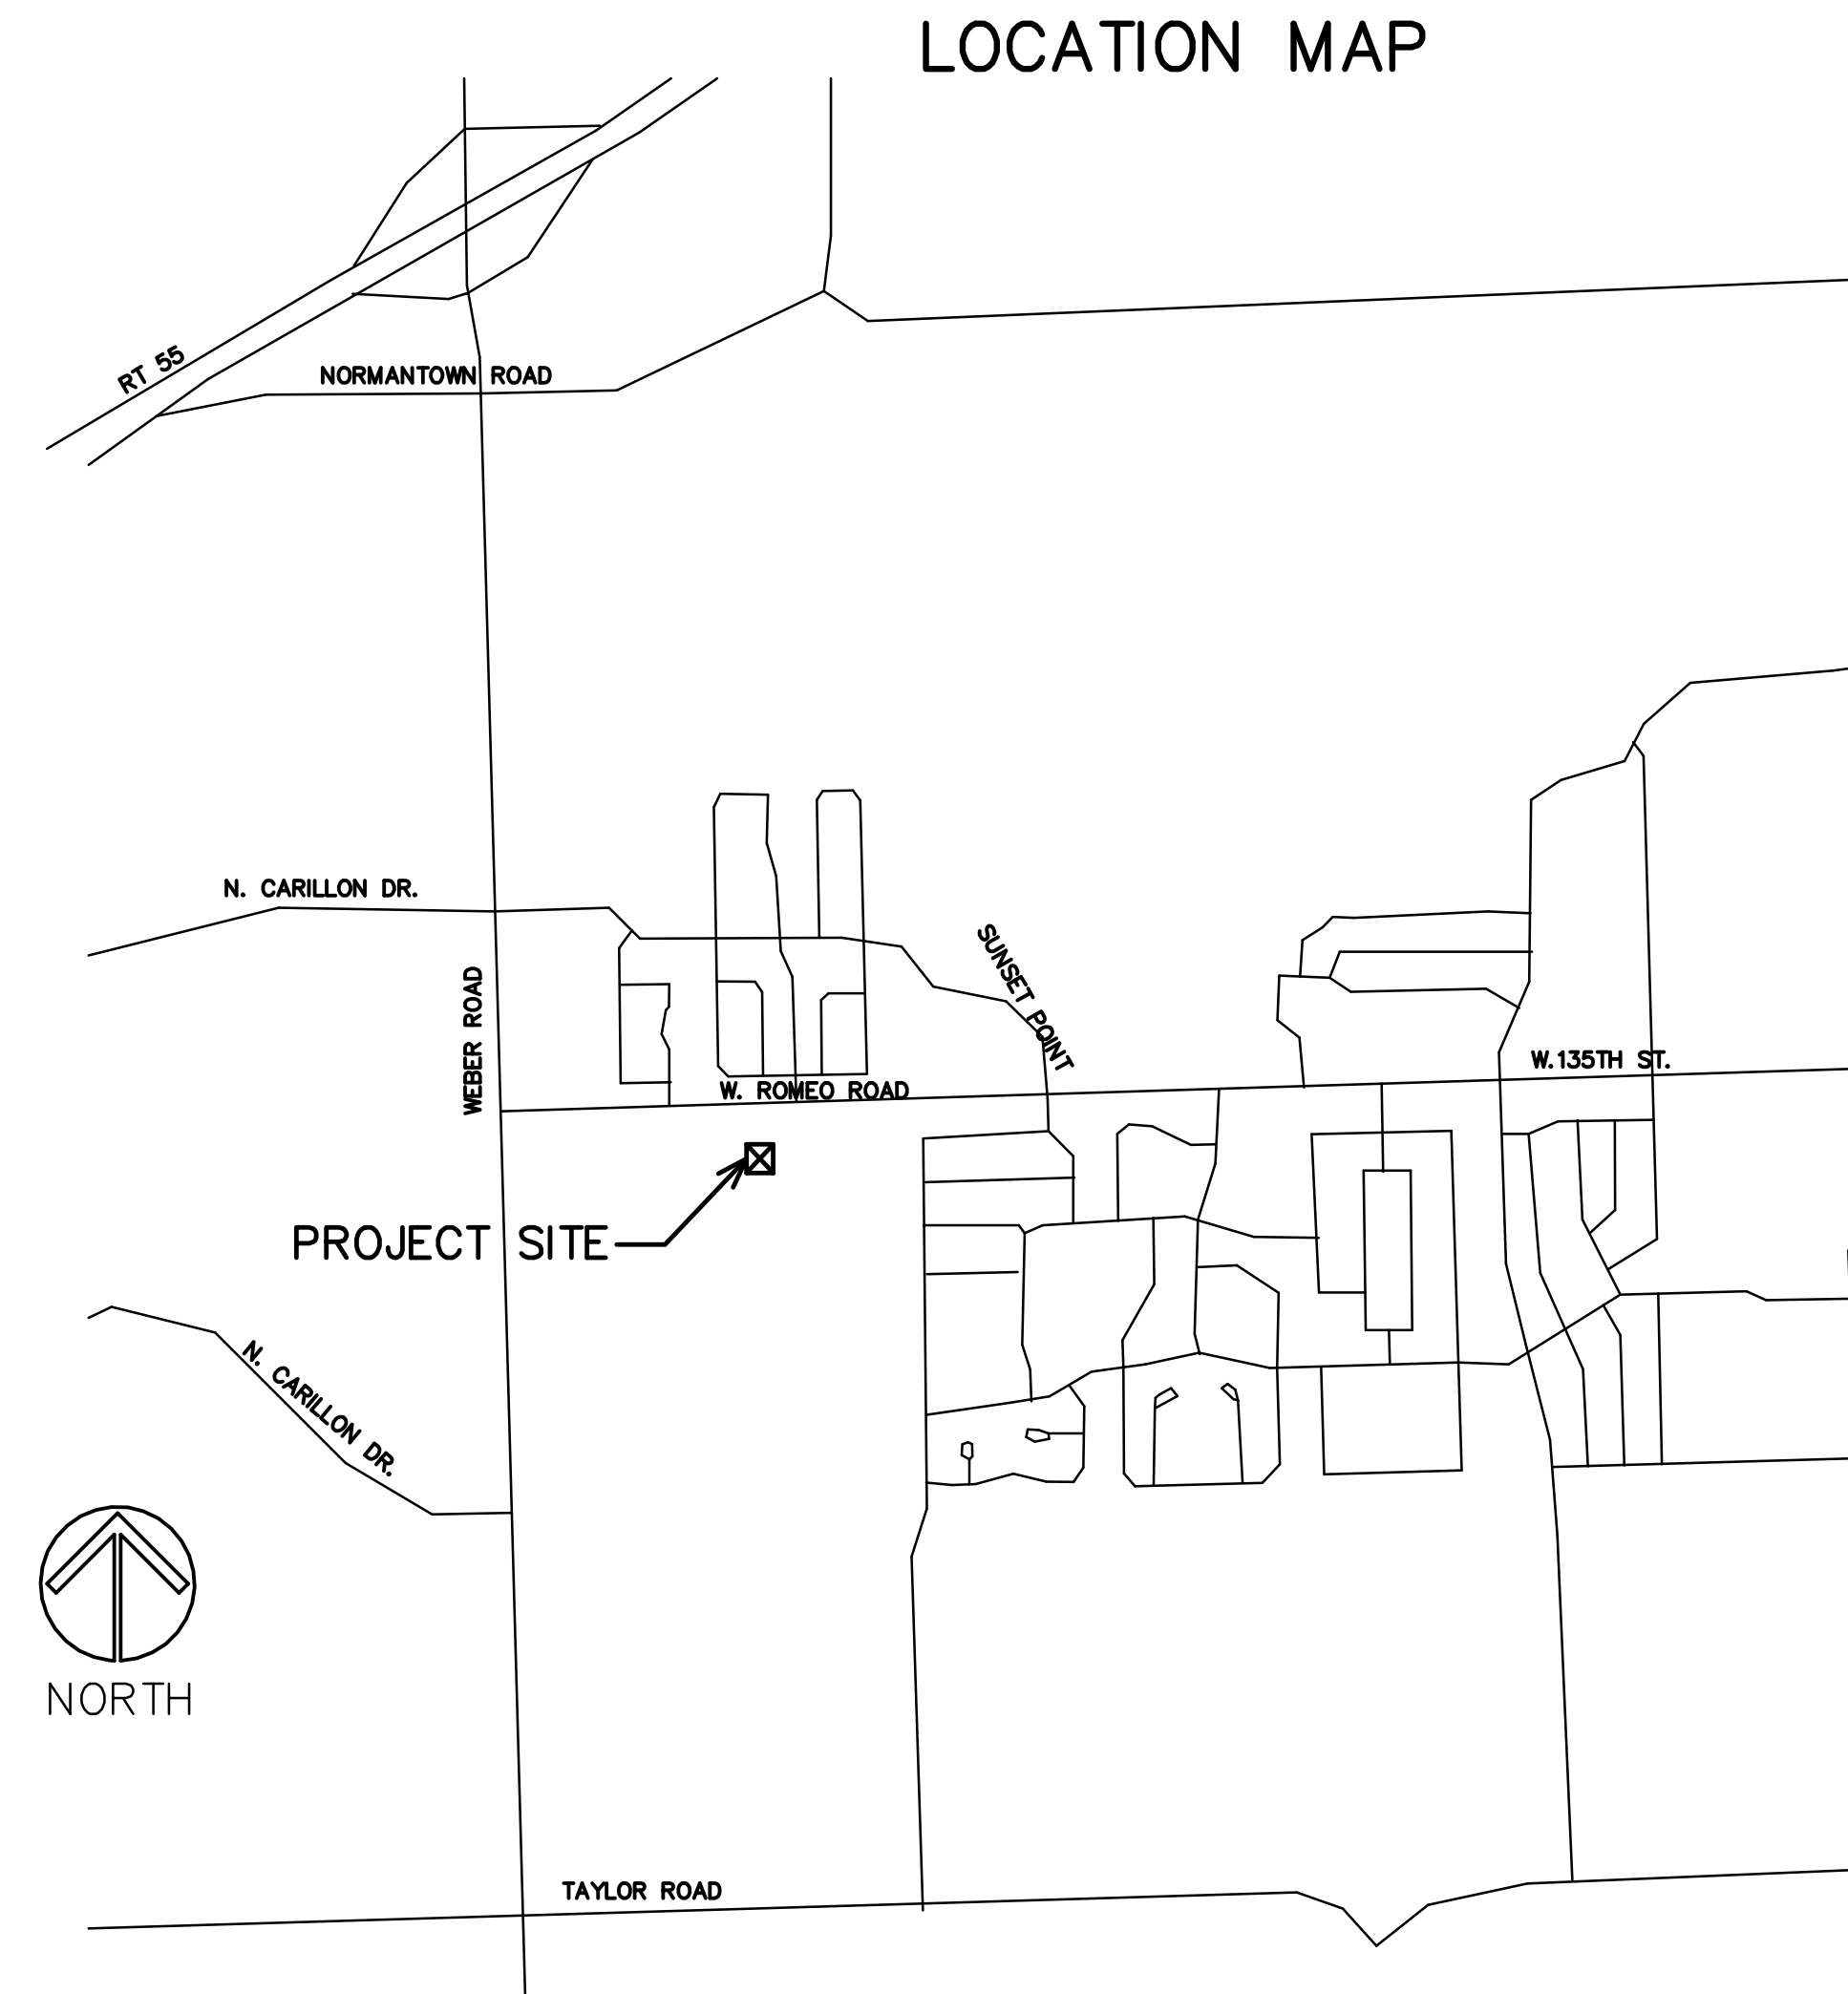

INDEX OF SHEETS

- | | |
|----|--|
| T1 | PROJECT TITLE, LOCATION, INDEX OF SHEETS |
| D1 | PARTIAL FIRST LEVEL DEMO FLOOR PLAN |
| D2 | PARTIAL FIRST LEVEL DEMO CEILING PLAN |
| A0 | RMB KEY PLAN |
| A1 | PARTIAL FIRST LEVEL FLOOR PLAN AND INTERIOR ELEVATIONS |
| A2 | PARTIAL FIRST LEVEL CEILING PLAN AND DETAIL |

NETWORKING SECURITY AND CYBER SECURITY LABS

JOLIET JUNIOR COLLEGE- ROMEVILLE CAMPUS
ROOMS RMB 1028,RMB1050/1052
1125 W. ROMEO ROAD
ROMEDEVILLE, ILLINOIS

STROMSLAND + DE YOUNG + PRYBYS
ARCHITECTURE GROUP

20620 BURL COURT
JOLIET, IL 60433
PHONE: 815-727-1311
FAX: 815-727-5210

COPYRIGHT 2022 © S D P ARCHITECTURE GROUP, INC.

REGISTRATION

SEAL

stromsland + de young + prybys
ARCHITECTURE GROUP
20620 Burl Court - 102
Joliet, Illinois 60433
www.sdpagroup.com
815-727-1311
L. N. : 184-000437

NUMBER

SET

NETWORKING SECURITY AND CYBER SECURITY LABS
JOLIET JUNIOR COLLEGE- ROMEVILLE CAMPUS
1125 W. ROMEO ROAD
ROMEDEVILLE, ILLINOIS

DATE:
3/11/2022
REVISED:


PROJECT NO.
2111-01

SHEET NUMBER


T1

OF 1 SHEETS

\\192.168.1.137\CURRENT PROJECTS\JJC ROMEVILLE CAMPUS- CISCO LAB RENOVATIONS\DRAWINGS\ARCH\DLAEC

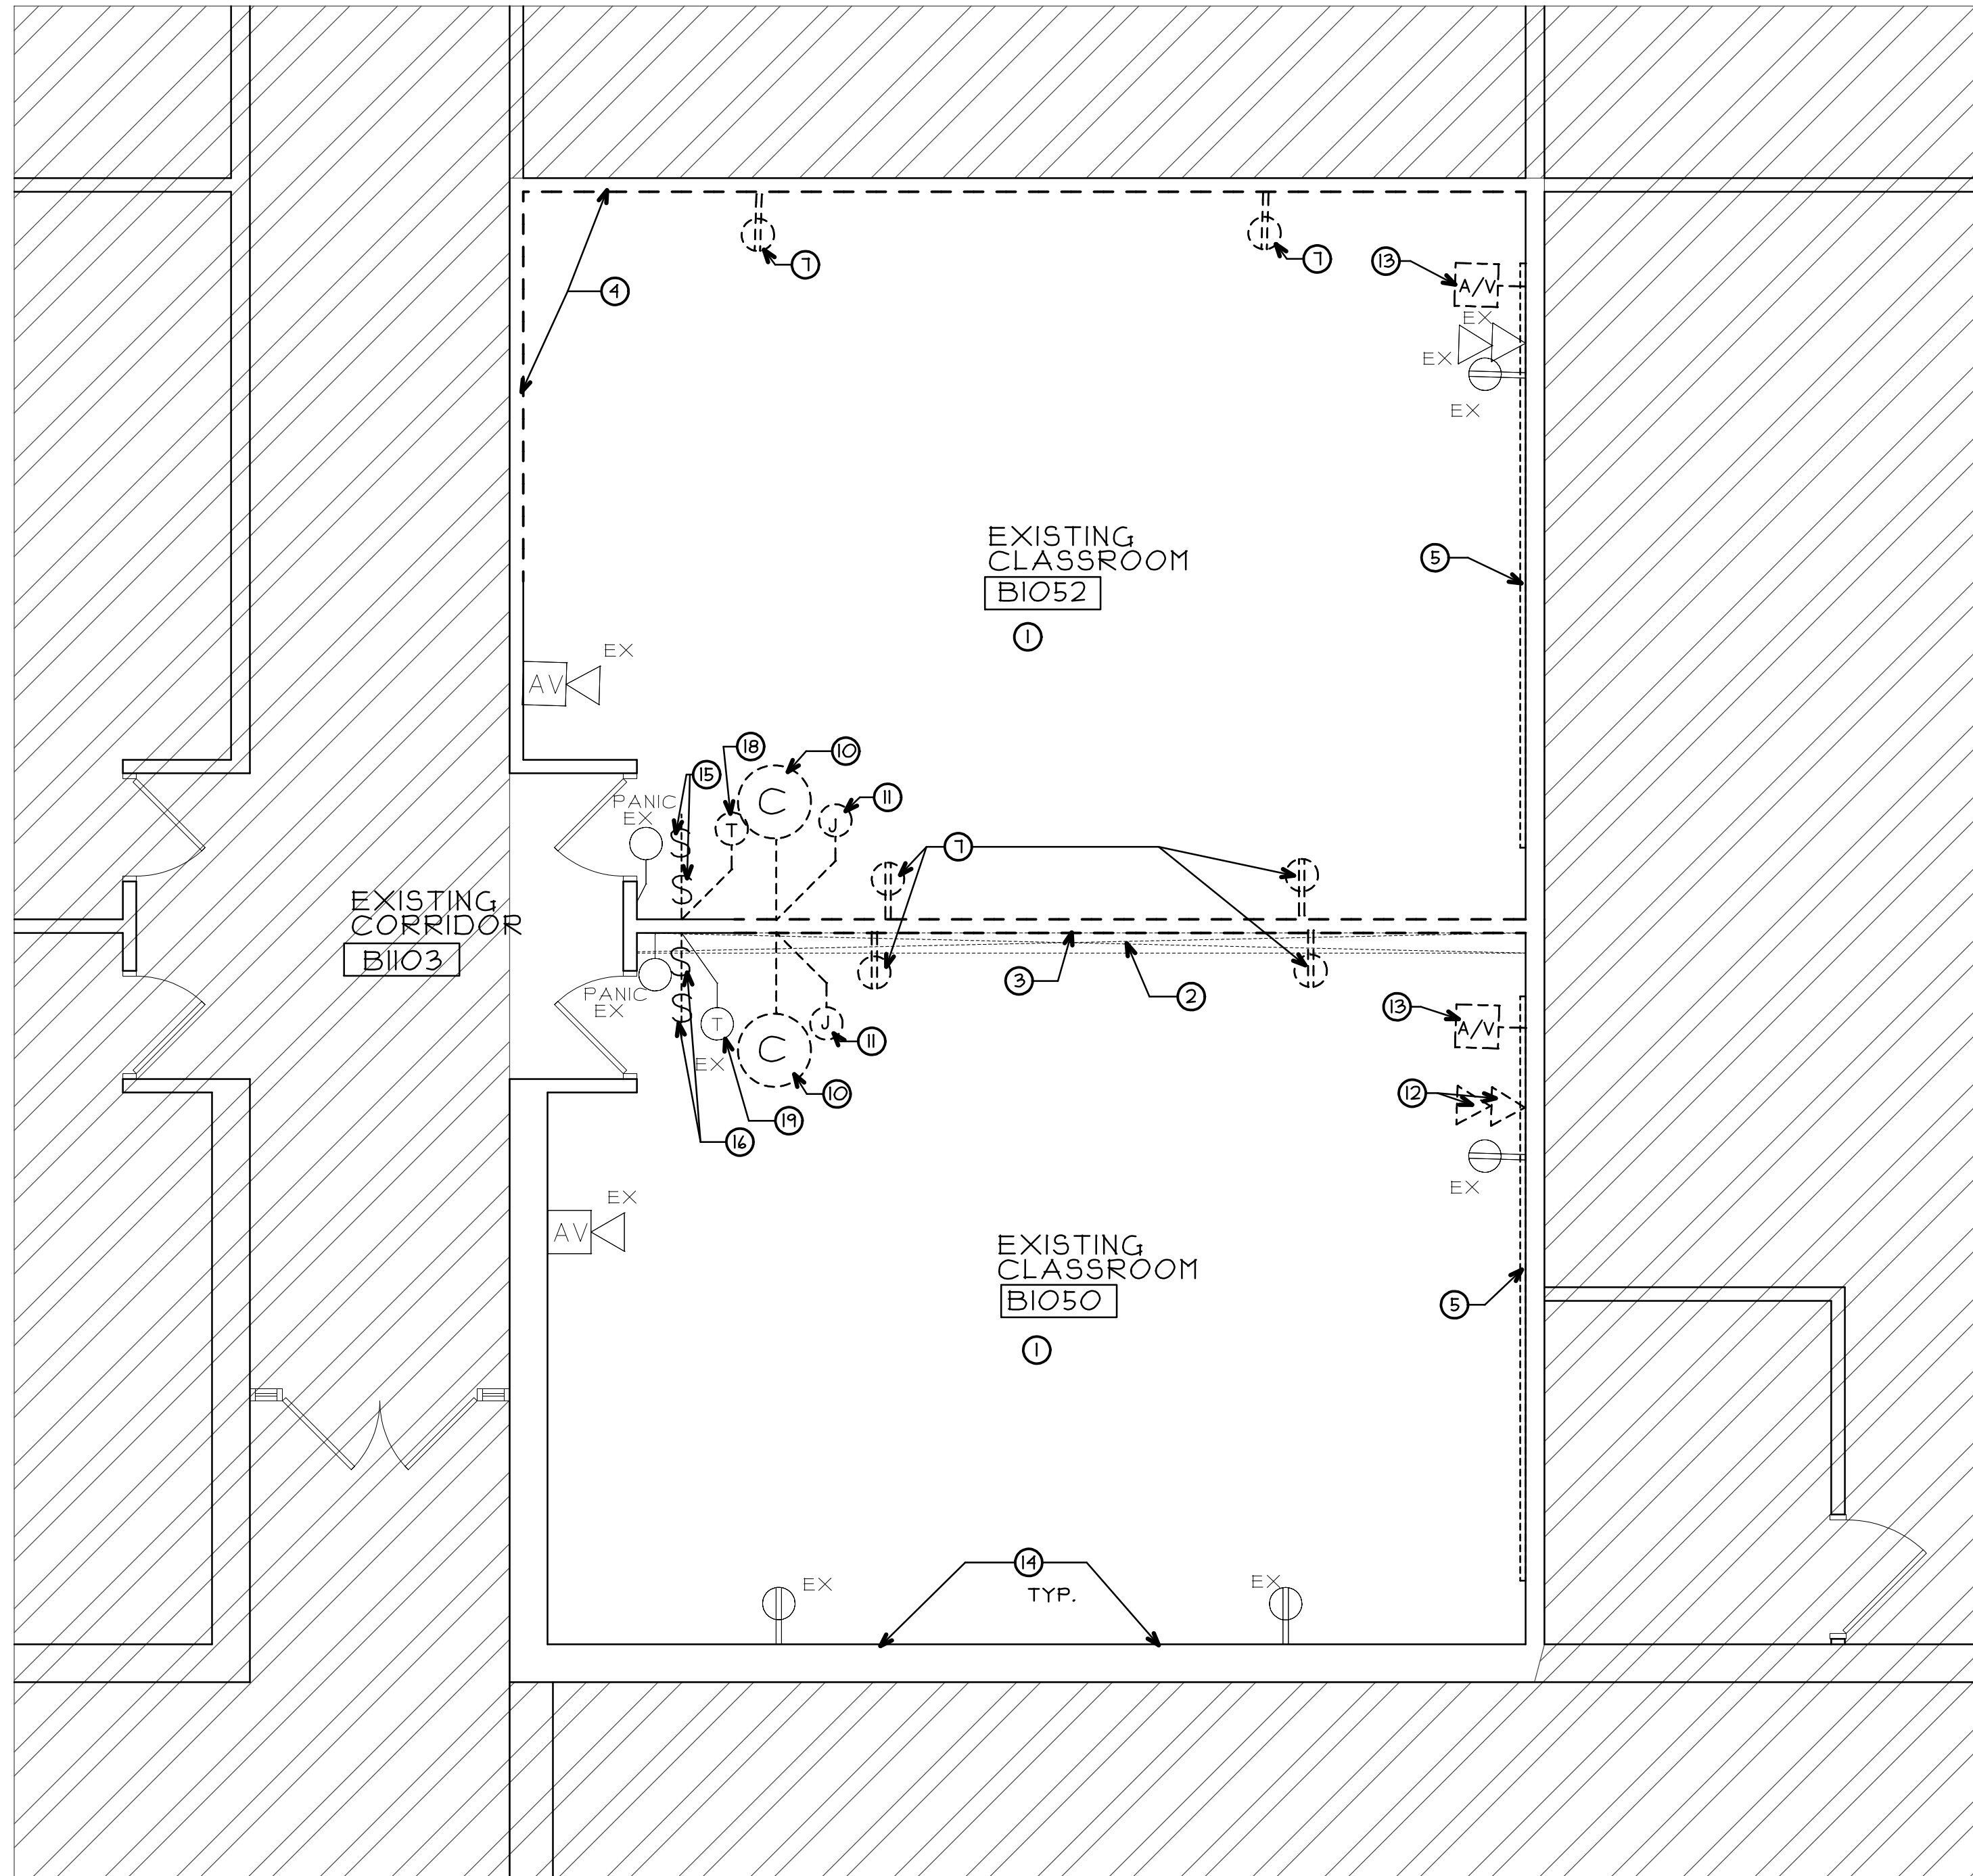

**PARTIAL FIRST FLOOR
DEMOLITION FLOOR PLAN**
NORTH SCALE: 1/4" = 1'-0"

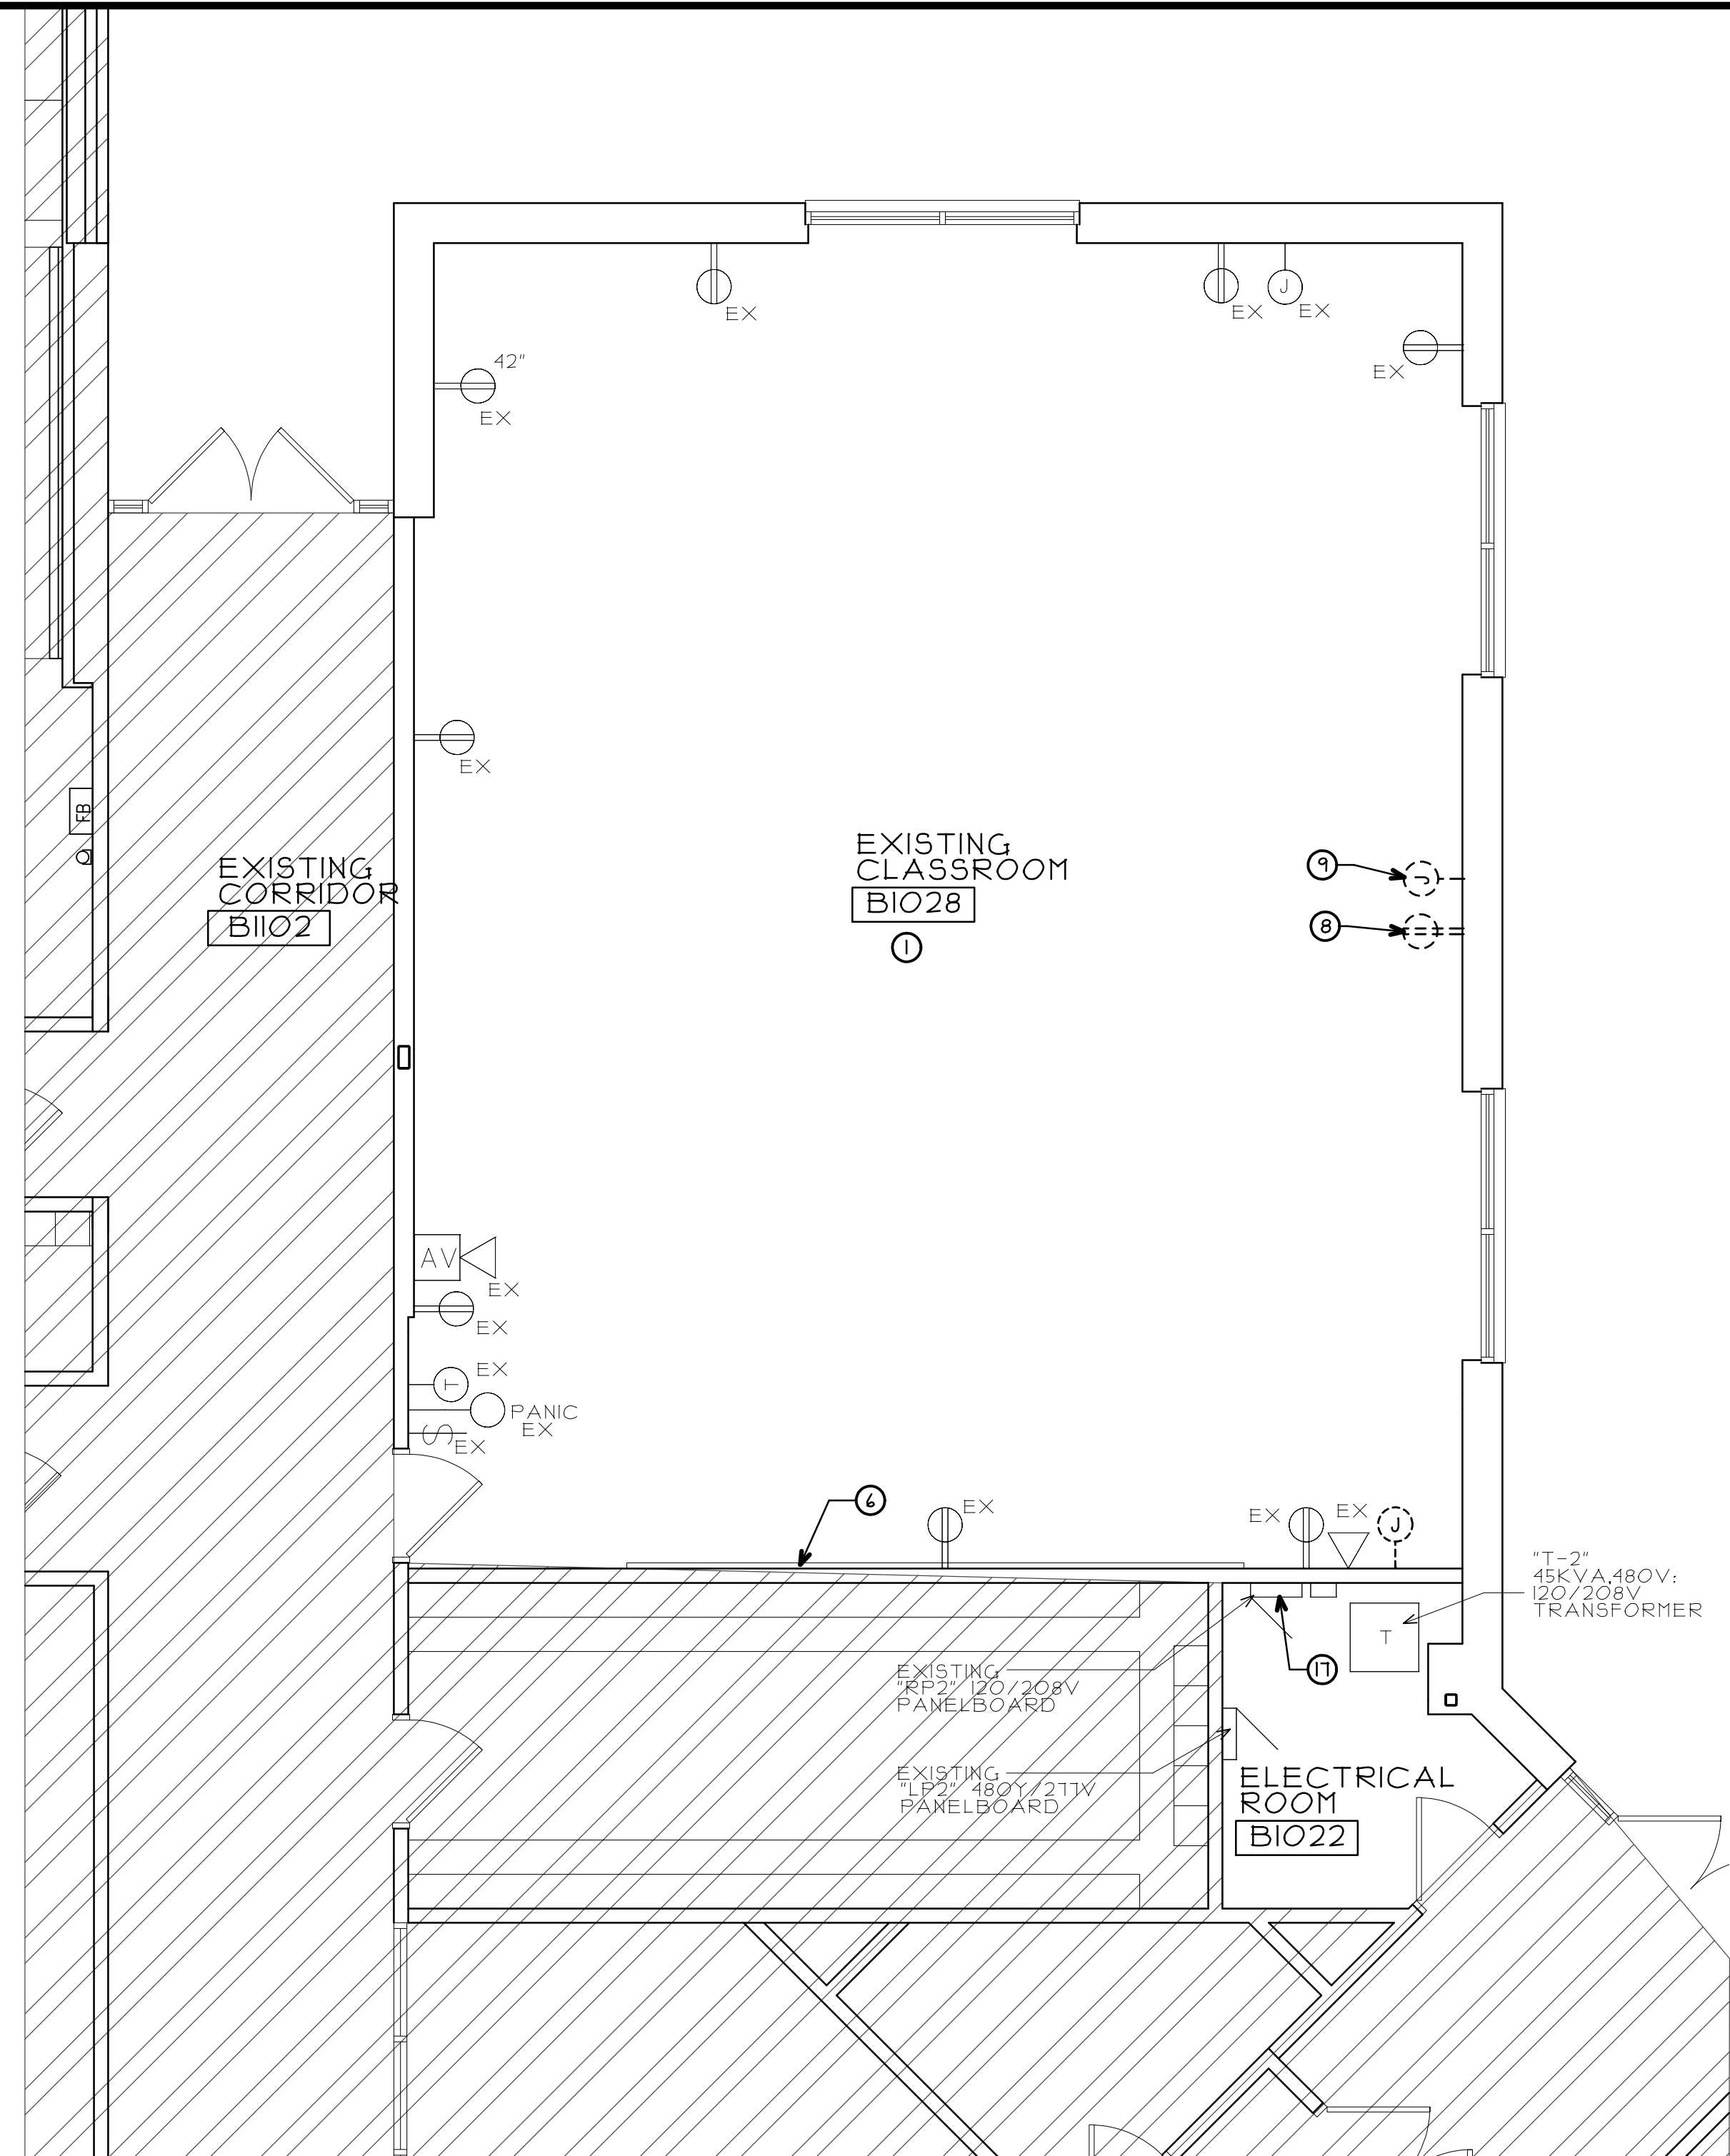

**PARTIAL FIRST FLOOR
DEMOLITION FLOOR PLAN**
NORTH SCALE: 1/4" = 1'-0"

DEMOLITION PLAN LEGEND

- HATCH DENOTES AREAS NOT INCLUDED IN PROJECT SCOPE.
- EXISTING WALLS TO REMAIN (TYPICAL)
- EXISTING METAL STUD AND GYPSUM BOARD WALL TO BE REMOVED COMPLETELY (UNLESS NOTED OTHERWISE) VERIFY IN FIELD
- EXISTING DOOR & FRAME TO REMAIN (TYPICAL)

DEMOLITION PLAN GENERAL NOTES

- ALL SALVAGED ITEMS NOT REUSED SHALL BE PLACED IN STORAGE, ON SITE, AT A LOCATION DESIGNATED BY THE OWNER.
- ALL ITEMS REMOVED AND NOT SALVAGED SHALL BE PROPERLY DISPOSED OF OFF SITE BY THE CONTRACTOR.
- PATCH & REPAIR HOLES AND/OR DAMAGED SURFACES CAUSED TO ADJACENT CONSTRUCTION DURING DEMOLITION.
- VERIFY ANY ADDITIONAL DEMOLITION WORK REQUIRED FOR INSTALLATION OF DEVICES/EQUIPMENT.
- EXISTING FURNITURE AND MOVABLE EQUIPMENT TO BE REMOVED BY OWNER'S STAFF. ANYTHING THAT REMAINS CONTRACTOR TO COORDINATE WITH OWNER FOR STORAGE LOCATION. (V.I.F.)
- DEVICES INDICATED WITH AN "EX" ARE TO BE EXISTING TO REMAIN. (V.I.F.)

DEMOLITION PLAN KEY NOTES

- EXISTING V.C.T. FLOORING TO REMAIN (U.N.O.). PROVIDE PROTECTION AS NEEDED DURING CONSTRUCTION.
- REMOVE CUT V.C.T. FLOORING ALONG WALL. (V.I.F.)
- REMOVE PORTION OF EXISTING GYPSUM BOARD AND METAL STUD FRAMING FROM FLOOR UP TO ±2" FROM CEILING. SEE DETAIL 1 ON SHEET A2.
- REMOVE 4'-0" HIGH AREA OF GYPSUM BOARD ALONG WALL, TOP OF AREA TO BE 4'-0" A.F.F. DOWN 4'-0" EXISTING FRAMING TO REMAIN.
- EXISTING WHITE BOARD TO BE REMOVED AND SALVAGED TO OWNER. (V.I.F.)
- EXISTING WHITE BOARD TO BE REMAIN. (V.I.F.)
- EXISTING DUPLEX RECEPTACLE, BOX, CONDUIT AND WIRING TO BE REMOVED BACK TO EXISTING JUNCTION BOX TO REMAIN. (V.I.F.)
- EXISTING DUPLEX RECEPTACLE DEVICE AND PLASTER RING TO BE REMOVED. EXISTING LOCATION TO REMAIN FOR NEW QUAD OUTLET SEE FLOOR PLAN. MODIFY WIRING AS NECESSARY (V.I.F.)
- BLANK COVER PLATE TO BE REMOVED. EXISTING JUNCTION BOX LOCATION TO REMAIN FOR REUSE SEE FLOOR PLAN. (V.I.F.)
- EXISTING CLOCK/ COMBINATION SPEAKER UNIT TO BE COMPLETELY REMOVED. EXISTING POWER WIRING BE EXTENDED TO NEW CLOCK LOCATION. SPEAKER WIRING TO BE REMOVED BACK TO EXISTING JUNCTION BOX TO REMAIN. (V.I.F.) EXISTING CLOCK TO BE SALVAGED TO OWNER
- EXISTING INTERCOM CALL SWITCH TO BE REMOVED COMPLETELY AND WIRING TO BE PROPERLY TERMINATED AT EXISTING JUNCTION BOX TO REMAIN ABOVE CEILING. (V.I.F.)
- EXISTING DATA OUTLET DEVICES TO BE REMOVED AND DATA CABLING TO BE COILED ABOVE CEILING FOR OWNER'S FUTURE USE. PATCH WALL WITH LIKE MATERIALS. (V.I.F.)
- EXISTING AUDIO VISUAL CONNECTION PORT BE REMOVED WIRING TO BE PROPERLY TERMINATED ABOVE CEILING AND PATCH WALL WITH LIKE MATERIALS. (V.I.F.)
- EXISTING SURFACE MOUNTED IMPACT PROTECTION CHAIR RAIL TO BE REMOVED. PATCH AND PREP WALL FOR NEW FINISH. (V.I.F.)
- EXISTING SWITCHES TO BE REMOVED AND SWITCH LEG DEMOLISHED BACK TO NEAREST FIXTURE AND PROPERLY TERMINATED. PROVIDE BLANK STAINLESS STEEL COVERPLATE.
- EXISTING SWITCHES TO BE REMOVED. LOCATION TO REMAIN FOR REUSE. SEE NEW CEILING PLAN.
- DISCONNECT EXISTING CIRCUITS 31,39 AND 41 AND FIT NEW 40A-3P CIRCUIT BREAKER (MATCH EXISTING TYPE) FOR NEW SUBFEED. (V.I.F.)
- EXISTING THERMOSTAT TO BE REMOVED AND WIRING TO BE CONNECTED TO OTHER THERMOSTAT TO REMAIN. PATCH WALL WITH LIKE MATERIAL
- EXISTING THERMOSTAT TO REMAIN. (V.I.F.)

COPYRIGHT 2022 © S D P ARCHITECTURE GROUP, INC.

REGISTRATION

SEAL

stromsland + de young + prybys
ARCHITECTURE GROUP
20620 Burl Court - 102
Joliet, Illinois 60438
www.sdpagroup.com
815-727-1311
L.N.: 184-00437

NUMBER

SET

NETWORKING SECURITY AND CYBER SECURITY LABS
JOLIET JUNIOR COLLEGE- ROMEVILLE CAMPUS
1125 W. ROME ROAD
ROMEVILLE, ILLINOIS

DATE: 3/11/2022
REVISED:


PROJECT NO.
2111-01

SHEET NUMBER

D1

OF 2 SHEETS

\\192.168.1.137\CURRENT PROJECTS\JUC ROMEOVILLE CAMPUS- CISO LAB RENOVATIONS\DRAWINGS\ARCH\D2AEC

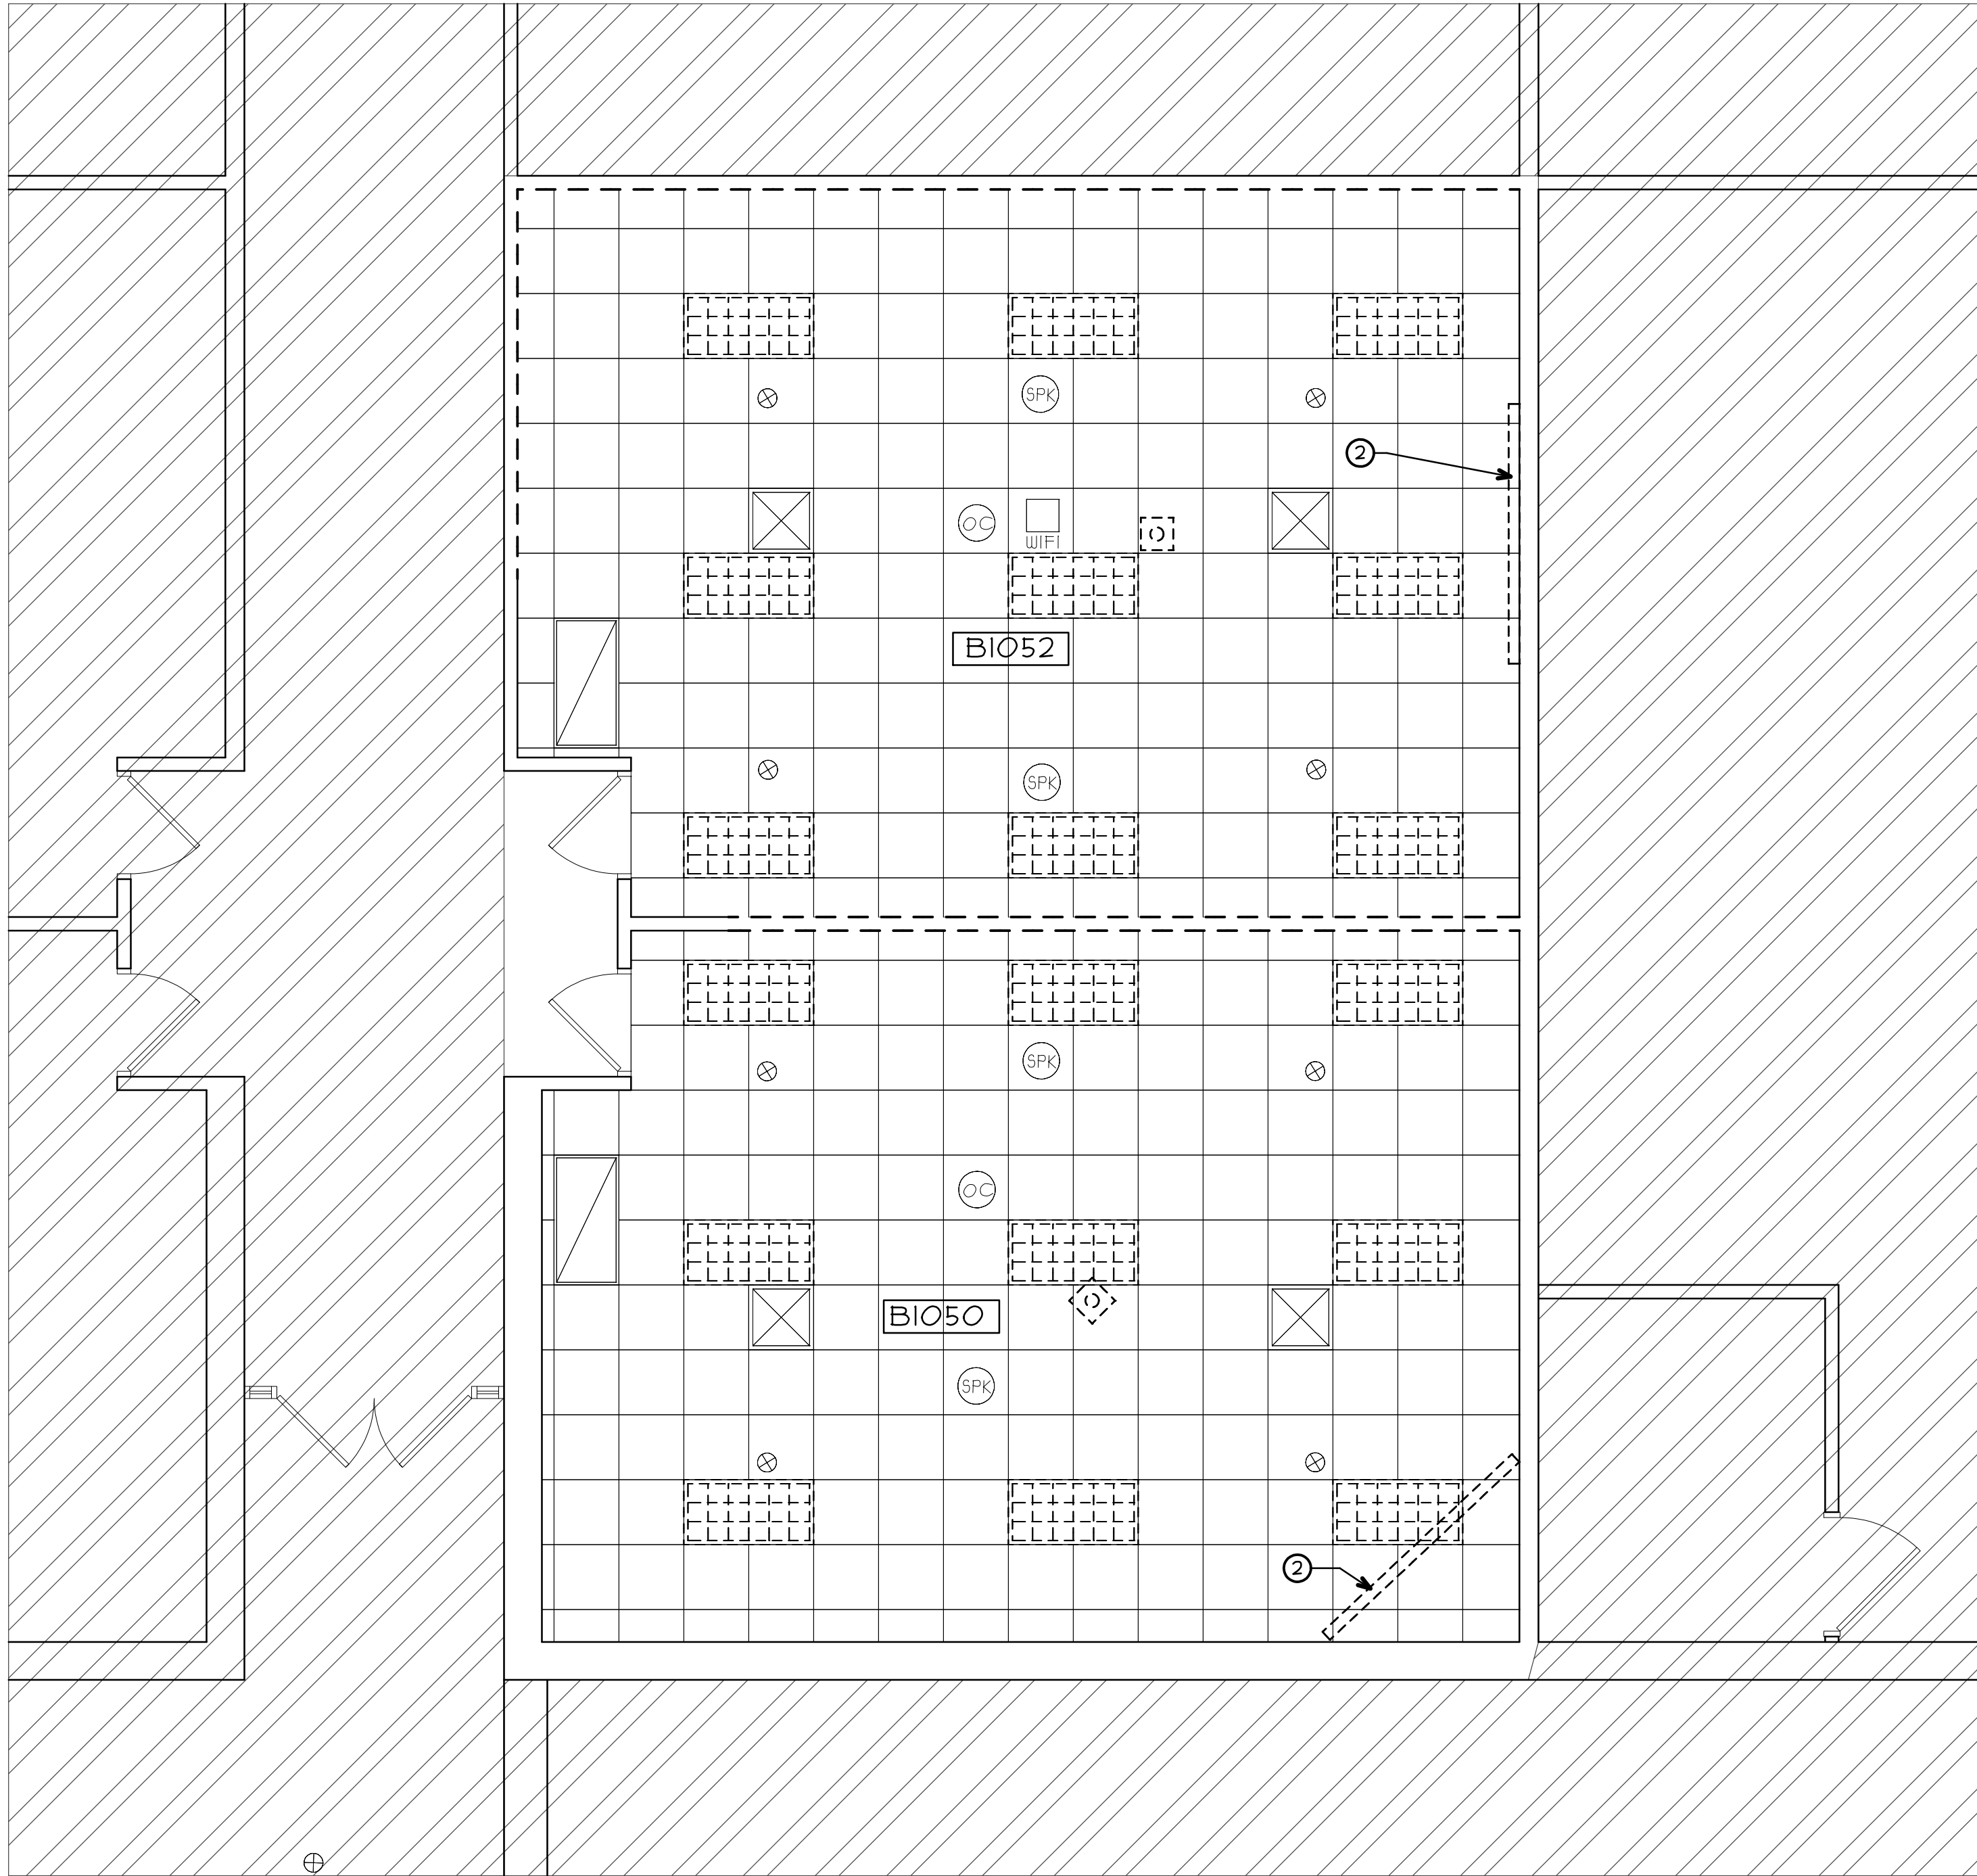

**PARTIAL FIRST FLOOR
DEMO CEILING PLAN**
NORTH SCALE: 1/4" = 1'-0"

DEMO CEILING PLAN LEGEND


	HATCH DENOTES AREAS NOT INCLUDED IN PROJECT SCOPE		DENOTES EXISTING WIFI ANTENNA TO REMAIN
	DENOTES EXISTING 2' X 2' SUSPENDED CEILING GRID SYSTEM AND ACOUSTICAL PANELS TO REMAIN (U.N.O.)		DENOTES EXISTING AUDIO SPEAKER TO REMAIN
	DENOTES EXISTING LAY-IN LIGHTING FIXTURE IN ACOUSTIC CEILING. SEE ELECTRICAL DRAWINGS		DENOTES EXISTING PROJECTOR MOUNT TO REMAIN (V.I.F.)
	DENOTES EXISTING LAY-IN LIGHTING FIXTURE TO BE REMOVED. EXISTING WIRING TO REMAIN FOR REUSE (V.I.F.)		DENOTES EXISTING PROJECTOR MOUNT TO BE COMPLETELY REMOVED. SALVAGE FOR POSSIBLE REUSE (V.I.F.)
	DENOTES EXISTING LAY-IN SUPPLY DIFFUSER IN ACOUSTIC CEILING. SEE MECHANICAL NOTES		
	DENOTES EXISTING LAY-IN RETURN REGISTER IN ACOUSTIC CEILING. SEE MECHANICAL NOTES		
	DENOTES EXISTING SPRINKLER HEAD LOCATION IN CEILING/SOFFIT TO REMAIN.		
	DENOTES EXISTING OCCUPANCY SENSOR TO REMAIN		

DEMO CEILING PLAN GENERAL NOTES


- ALL SALVAGED ITEMS NOT REUSED SHALL BE PLACED IN STORAGE, ON SITE, AT A LOCATION DESIGNATED BY THE OWNER.
- ALL ITEMS REMOVED AND NOT SALVAGED SHALL BE PROPERLY DISPOSED OF OFF SITE BY THE CONTRACTOR.
- PATCH & REPAIR ALL EXISTING GYPSUM BOARD SURFACES TO "LIKE NEW" CONDITION PRIOR TO INSTALLING NEW FINISHES.
- COORDINATE WITH AND ALLOW OWNER'S SEPARATE VENDORS ACCESS TO CEILING INTERSTITIAL SPACES FOR INSTALLATION OF WIRING AND EQUIPMENT PRIOR TO INSTALLING LAY IN CEILING PANELS.

DEMO CEILING PLAN KEY NOTES


- REMOVE PORTION OF EXISTING CEILING PANELS AND GRID FOR NEW CEILING MOUNTED HVAC UNIT. SALVAGE GRID AND PANELS FOR REUSE (V.I.F.)
- EXISTING DROP DOWN PROJECTION SCREEN AND BRACKETS TO BE COMPLETELY REMOVED. SALVAGE TO OWNER (V.I.F.)

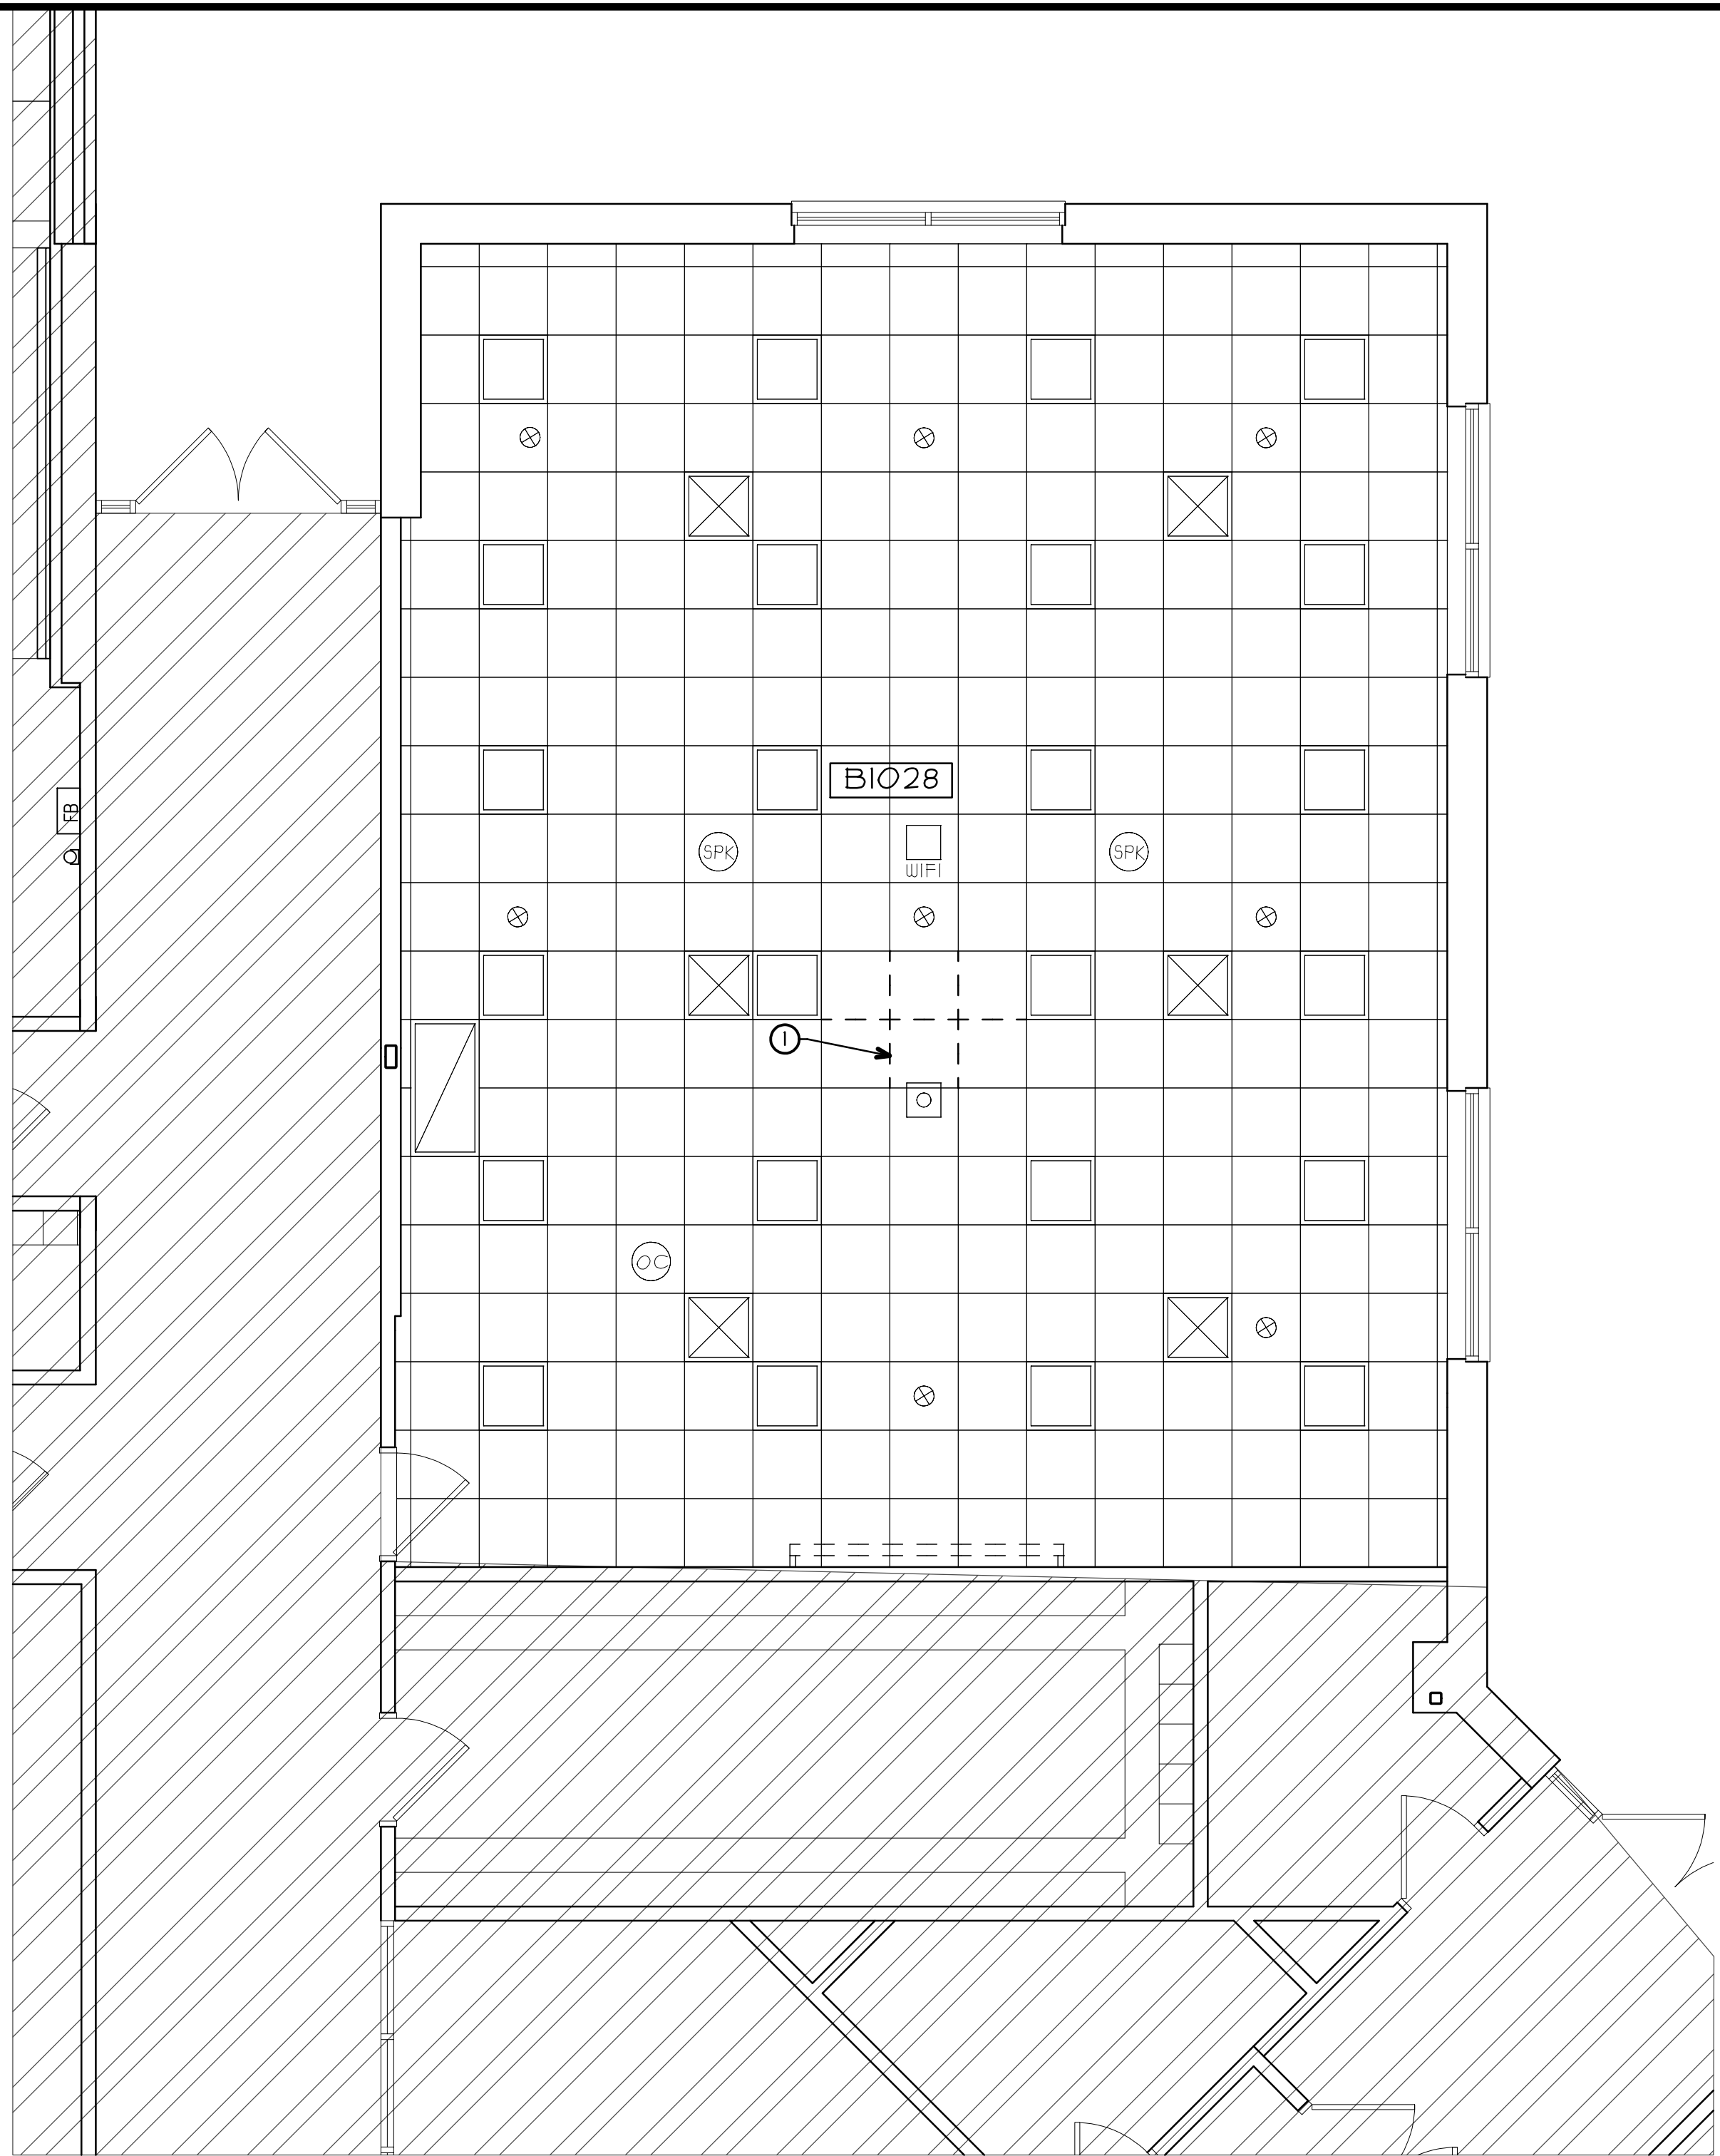

**PARTIAL FIRST FLOOR
DEMO CEILING PLAN**
NORTH SCALE: 1/4" = 1'-0"

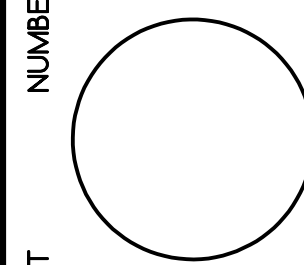

\\192.168.1.137\CURRENT PROJECTS\JJC ROMEOVILLE CAMPUS- CISCO LAB RENOVATIONS\DRAWINGS\ARCH\AO.AEC

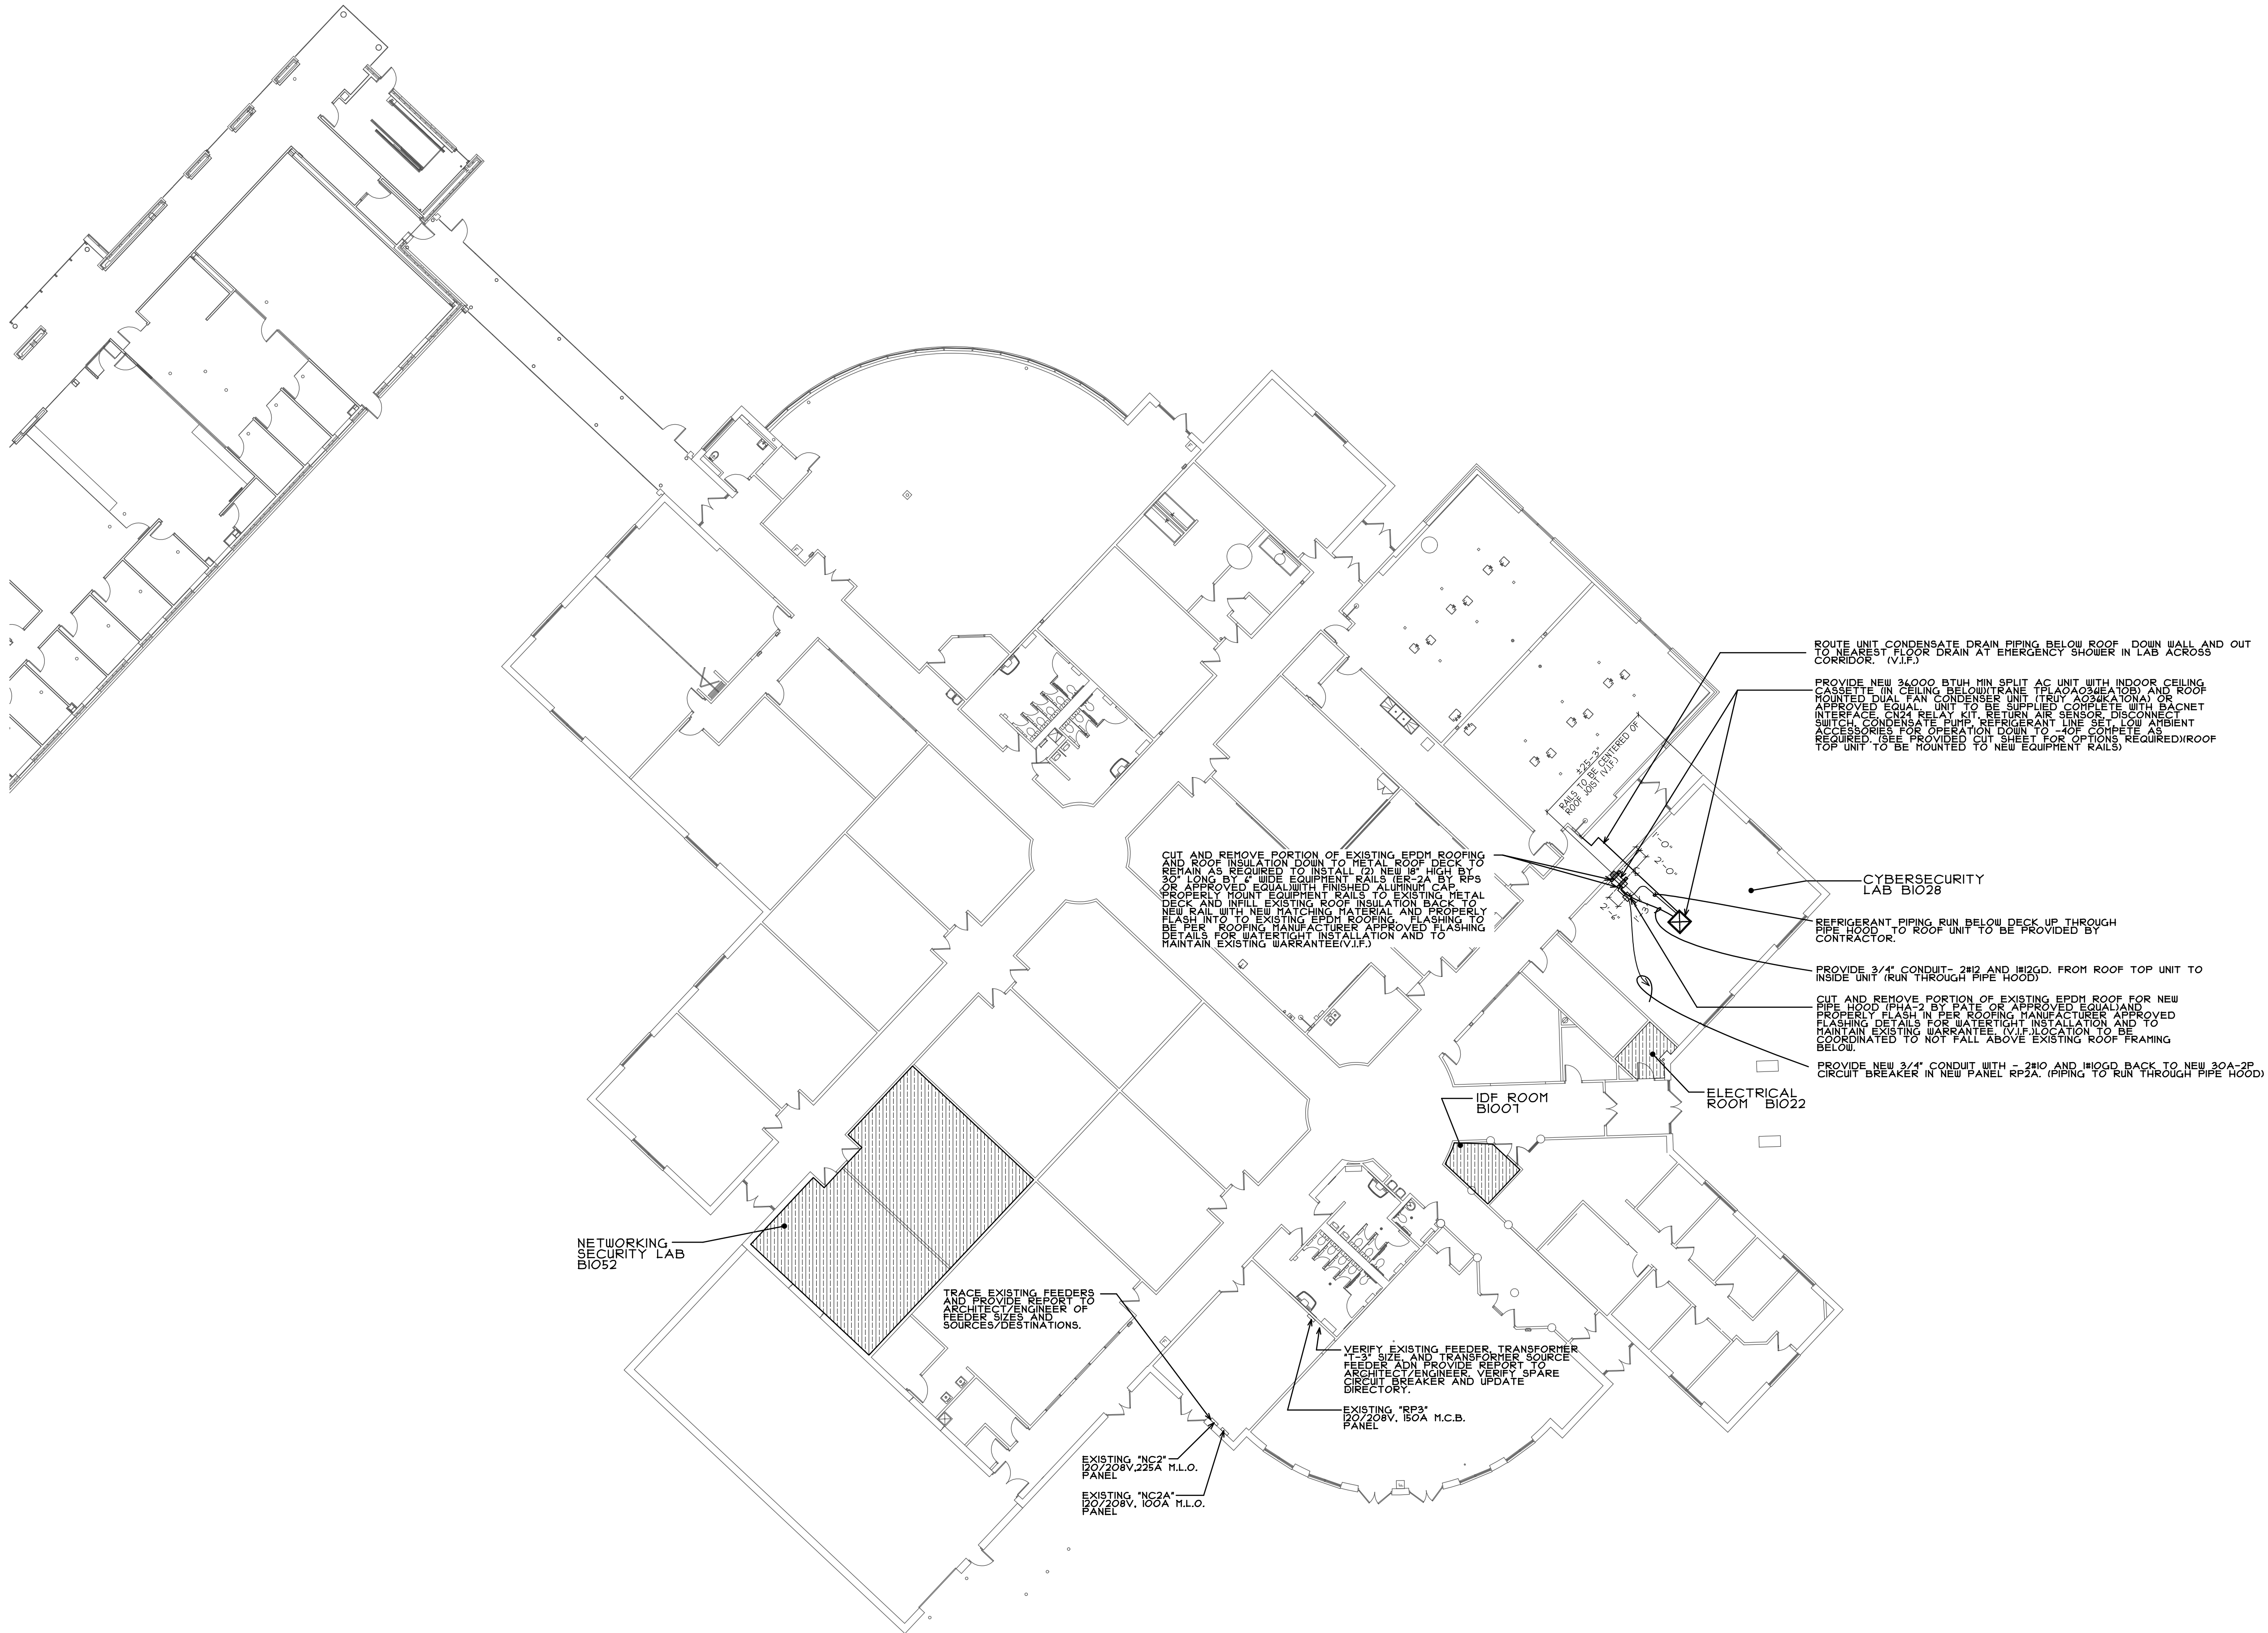

 **KEY PLAN**
SCALE: 1/16" = 1'-0"

REGISTRATION

SEAL

stromsland + de young + prybys
ARCHITECTURE GROUP
20620 Burr Court - 102
Joliet, Illinois 60433
www.sdpagroup.com
815-727-1311
L.N.: 184-00437

SET
NUMBER

NETWORKING SECURITY AND CYBER SECURITY LABS
JOLIET JUNIOR COLLEGE- ROMEOVILLE CAMPUS
1125 W. ROMEO ROAD
ROMEOVILLE, ILLINOIS

DATE: 3/11/2022
REVISED:


PROJECT NO.
2111-01

SHEET NUMBER

AO

OF 3 SHEETS

\\192.168.1.137\current projects\jlc romeoville campus- cisco lab renovations\drawings\arch\valaec

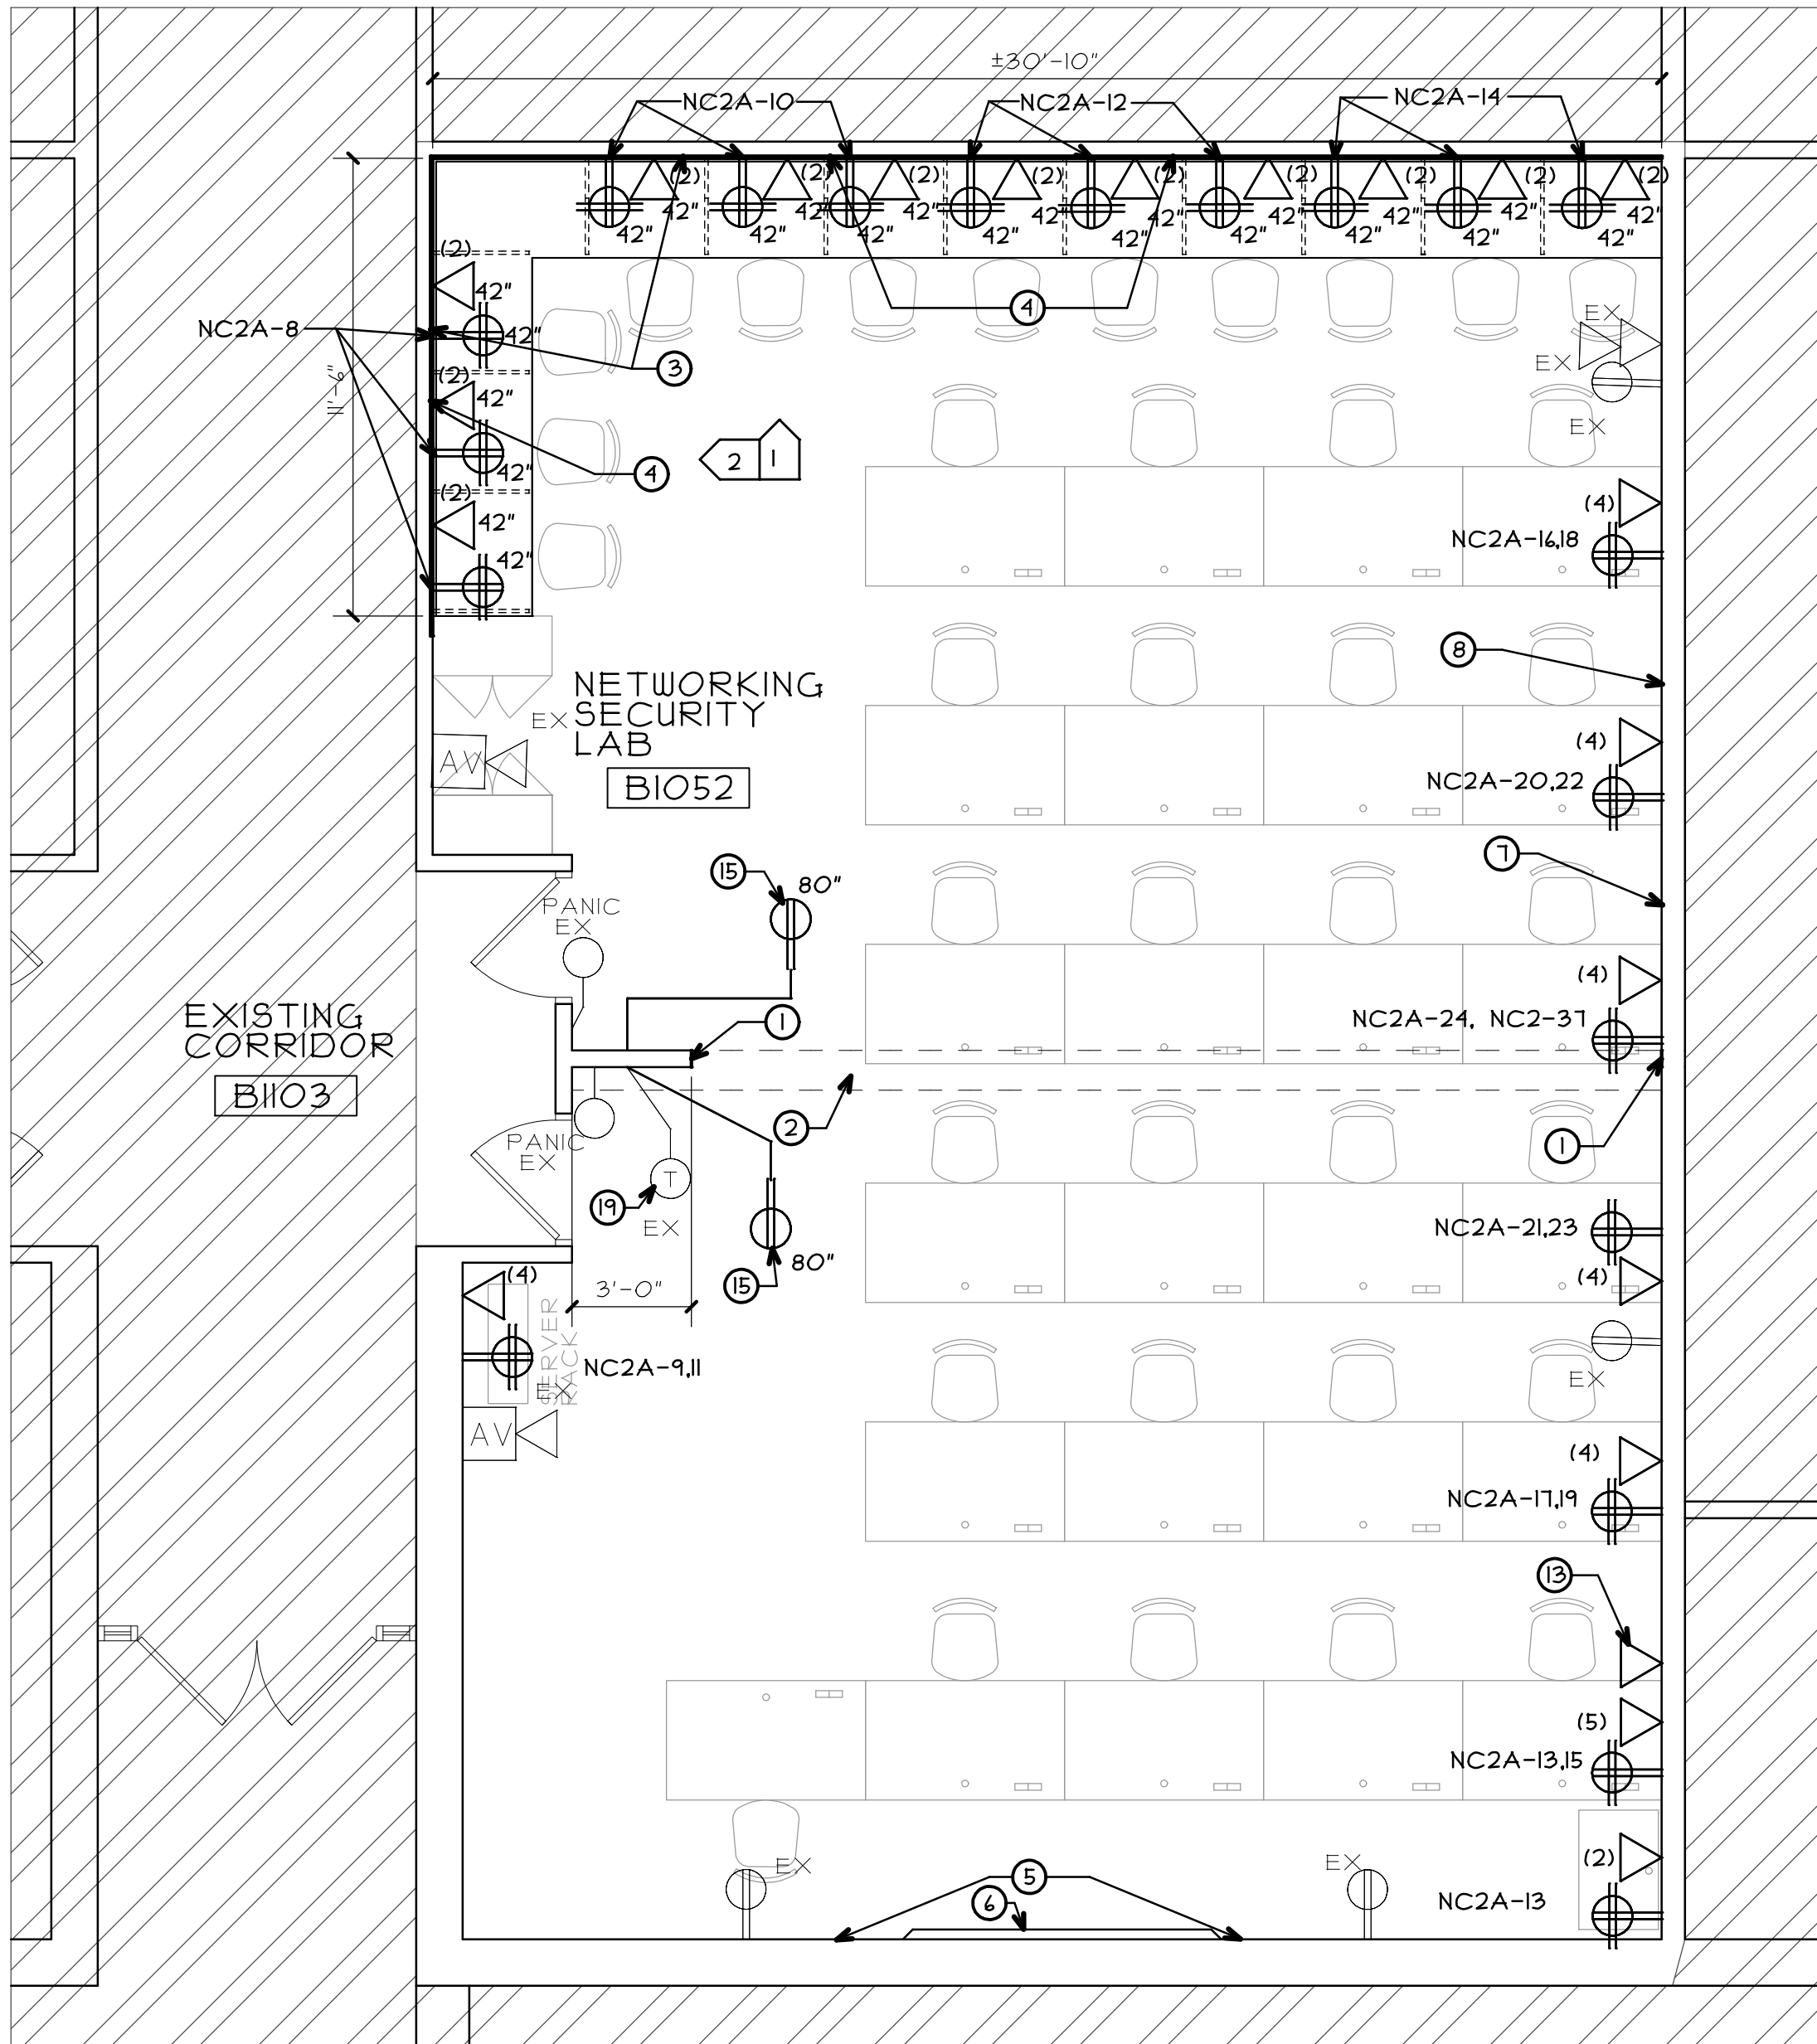

PARTIAL FIRST FLOOR PLAN
NORTH SCALE: 1/4" = 1'-0"

FLOOR PLAN KEY NOTES

- AT LOCATIONS OF REMOVED WALLS (SEE DEMOLITION PLANS). EXISTING WALLS TO REMAIN ARE TO BE PATCHED WITH "LIKE" MATERIALS MATCHING ADJOINING (SIZE, THICKNESS, ETC.) V.I.F. (PATCH IN WALL BASE WITH NEW MATCHING MATERIAL).
- PATCH IN FLOOR WITH NEW VCT FLOORING. (BLUE/GRAY #51903 IMPERIAL TEXTURE STANDARD BY ARISTON) TO MATCH EXISTING FLOORING. (V.I.F.)
- PROVIDE CONTINUOUS 18" HIGH IN WALL BLOCKING FOR NEW WALL MOUNTED MONITOR BRACKETS FURNISHED BY OWNER AND INSTALLED BY CONTRACTOR ALONG NEW COUNTER. TOP OF BLOCKING TO START AT 5'-8" A.F.F.
- PATCH IN WALL WITH NEW MATCHING GYPSUM BOARD AND TAPE-IN TO EXISTING. (V.I.F.)
- PROVIDE 4'-0" HIGH FULL WALL WIDTH SURFACE APPLIED WHITE BOARD. FLEX WRITE SURFACE BY "POST-IT". MOUNT TOP AT 1'-0" A.F.F.
- PROVIDE 8'-0" WIDE SURFACE MOUNTED ALUMINUM MARKER TRAY WITH ANGLED CORNERS. OPTIMA- GR-ATLASRC-08 BY ATLASRAY OR APPROVED EQUAL. MOUNT AT CENTERLINE OF WALL UNDER BOTTOM EDGE OF SURFACE APPLIED WHITE BOARD.
- PROVIDE NEW CONTINUOUS SURFACE APPLIED CRASH RAIL ALONG THIS WALL. RS-40 BY CONSTRUCTION SPECIALTIES OR APPROVED EQUAL. COLOR TO BE SELECTED. MOUNTED AT 32" A.F.F. TO CENTERLINE.
- PROVIDE PAINTED ACCENT WALL (AC-1). (EGGSHELL FINISH)
- PROVIDE NEW DATA LOCATION AT BLANK JUNCTION BOX LOCATION. (V.I.F.)
- NEW QUAD RECEPTACLE TO BE AT LOCATION OF REMOVED DUPLEX OUTLET. (V.I.F.)
- PROVIDE NEW DATA OUTLET LOCATION. FEED TO RUN BACK TO IDF ROOM BOOT.
- PROVIDE NEW DATA OUTLET LOCATION. FEED TO RUN UP TO EXISTING PROJECTOR LOCATION. (V.I.F.) PROVIDE TO LABELED "PROJECTOR" COORDINATE WITH OWNER.
- PROVIDE NEW DATA OUTLET LOCATION. FEED TO RUN UP TO NEW PROJECTOR LOCATION. (SEE CEILING PLAN) PROVIDE TO LABELED "PROJECTOR" COORDINATE WITH OWNER.

- PROVIDE RECESSED SINGLE DATA PORT DEVICE AND RUN FEED BACK TO ACCESSIBLE RACEWAY IN ROOM BIO28. COORDINATE WITH OWNER.
- PROVIDE NEW RECESSED DUPLEX OUTLET FOR OWNER INSTALLED CLOSET AT THIS LOCATION. CONNECT TO EXISTING CIRCUIT FROM REMOVED CLOSET LOCATION. (V.I.F.)
- PROVIDE SINGLE GANG PLASTER RING MOUNTED AT 18" A.F.F. PROVIDE SINGLE GANG PLASTER RING AT WALL MOUNTED MONITOR (COORDINATE HEIGHT WITH OWNER PROVIDED MONITOR AND BRACKET) CONNECT WITH METAL RACEWAY (WIREMOLD 4000 OR APPROVED EQUAL) INSIDE WALL FROM TWO LOCATIONS AND STUD 180 ACCESSIBLE CEILING ABOVE. (WIRING AND DEVICES ARE PROVIDED AND INSTALLED BY OWNER) COVER TO BE PAINTED TO MATCH WALL. (AC-2)
- PROVIDE NEW IN WALL BLOCKING FOR NEW WALL MOUNTED TV MOUNTING BRACKET.
- PROVIDE NEW ELECTRIC PANELBOARD. "RP2A" 120/208V, SURFACE JOOA M.O. 42 POLE WITH (30) 20A-1P CIRCUIT BREAKERS AND (1) 30A-2P CIRCUIT BREAKER. RELOCATE EXISTING CIRCUITS 31,39 AND 41 FROM PANEL RP2 TO 2,4,4 IN THIS PANEL. (V.I.F.)
- EXISTING THERMOSTAT TO CONTROL ALL TERMINAL UNITS WITHIN THIS ROOM. PROVIDE ALL LABOR, MATERIALS, PROGRAMING AND SUPERVISION AS REQUIRED. EXISTING SPACE SENSOR IN BIO52 TO CONTROL THE TWO TERMINAL AIR UNITS IN NEW ROOM.
- EXISTING THERMOSTAT TO CONTROL ALL TERMINAL UNITS. NEW MINI SPLIT WITHIN THIS ROOM. PROVIDE ALL LABOR, MATERIALS, PROGRAMING AND SUPERVISION AS REQUIRED. EXISTING SPACE SENSOR IN ROOM TO CONTROL THE TWO EXISTING TERMINAL AIR UNITS AND NEW MINI SPLIT A.C. UNIT VIA BACNET INTERFACE PROVIDED WITH UNIT.

FLOOR PLAN LEGEND

- HATCH DENOTES AREAS NOT INCLUDED IN PROJECT SCOPE.
- EXISTING WALLS TO REMAIN (TYPICAL)
- EXISTING DOOR & FRAME TO REMAIN (TYPICAL)
- INTERIOR VIEWS INDICATED WITH THESE TAGS. REFERENCE ELEVATIONS KEYED BY THE INDICATED NUMBER ON DRAWING SHEET A1.
- EX DENOTES EXISTING DEVICE TO REMAIN AND DEVICE TO REMAIN ON EXISTING CIRCUIT
- DENOTES NEW QUAD RECEPTACLE OUTLET IN TWO GANG J BOX WITH TWO GANG PLASTER RING AND COVER PLATE. MOUNTED 18" A.F.F. (V.I.F.) DEVICE COLOR WHITE AND BRUSHED STAINLESS STEEL COVER PLATE TO MATCH FACILITY STANDARD.
- DENOTES NEW WHITE DATA OUTLET. MOUNTED AT 18" A.F.F. (V.I.F.) (NUMBER OF PORTS INDICATED) COORDINATE WITH OWNER (TYPICAL) PROVIDE CONDUIT STUBBED TO ABOVE CEILING. RUN NEW PANDUIT WHITE PLENUM RATED CAT6 CABLE BACK TO IDF ROOM BIO01 (FACILITY STANDARD IS WHITE CABLE)

FLOOR PLAN GENERAL NOTES


- VERIFY ALL EXISTING DIMENSIONS IN FIELD AND REPORT ALL DISCREPANCIES PRIOR TO NEW CONSTRUCTION.
- PATCH & REPAIR ALL EXISTING GYPSUM BOARD SURFACES TO "LIKE NEW" CONDITION PRIOR TO INSTALLING NEW FINISHES.
- NEW M-E-P SERVICES IN EXISTING METAL STUD AND GYPSUM BOARD WALLS MAY BE FINISHED RING AND COVER PLATE. COORDINATE WITH OWNER (TYPICAL) PROVIDE CONDUIT STUBBED TO ABOVE CEILING. RUN NEW PANDUIT WHITE PLENUM RATED CAT6 CABLE BACK TO IDF ROOM BIO01 (FACILITY STANDARD IS WHITE CABLE).
- PROVIDE ALL REQUIRED IN WALL BLOCKING FOR NEW/SALVAGED WALL HUNG EQUIPMENT. COORDINATE WITH OWNER FOR OWNER PROVIDED EQUIPMENT.
- FURNITURE AND EQUIPMENT (F.B.O.) SHOWN FOR REFERENCE ONLY UNLESS NOTED OTHERWISE.
- TYPICAL FACILITY BASE PAINT IS SNOW BOUND SW7004 BY SHERWIN WILLIAMS
- FACILITY STANDARD ACCENT PAINTS IS:
AC-1- KENSINGTON BLUE (840) BY BENJAMIN MOORE.
AC-2- AMBER COAST (50YR 23/36).
- EXISTING WALL BASE IS 4" HIGH RUBBER COVE BASE #40 BLACK BY JOHNSONITE.

ELECTRICAL GENERAL NOTES


- ELECTRICAL CONTRACTOR TO VERIFY EXISTING/NEW CIRCUITS REQUIRED AND UPDATE PANEL DIRECTORY. EXISTING CIRCUITS NOT REUSED SHALL BE LISTED AS SPARE
- ALL EQUIPMENT AND MATERIALS SHALL BE U.L. LABELED.
- ALL CIRCUITS SHALL INCLUDE DEDICATED NEUTRAL CONDUCTOR.
- ALL EQUIPMENT IS TO BE NEW, FURNISHED, INSTALLED AND WIRED BY E.C. UNLESS NOTED OTHERWISE.
- ALL WIRING SHALL BE IN CONDUIT OR OTHER CODE APPROVED MATERIAL. NO EXPOSED WIRING WITH BE APPROVED WITHOUT LOCAL CODE APPROVAL IN WRITING.
- E.C. SHALL PROVIDE AN UPDATED PANEL DIRECTORY. SHOW LOADS ON EACH CIRCUIT, ROOM NAME, DEVICES AND AREA SERVED. AND PROBE LIGHTING CIRCUITS AND SHOW WATTS CONNECTED.
- INSTALLATION SHALL MEET ALL ROMEOVILLE ELECTRICAL CODES AND E.C. IS RESPONSIBLE TO PAY ALL FEES, TAXES AND PERMITS AS REQUIRED.
- TRACE ALL EXISTING CIRCUITS TO REMAIN; LABEL EXISTING AND NEW COVERPLATES/ JUNCTION BOX COVERS WITH PANEL AND CIRCUIT NUMBERS IN PROJECT AREA.
- PROVIDE 3/4" MIN. CONDUITS FOR POWER AND 1" MIN CONDUITS FOR DATA.

MECHANICAL GENERAL NOTES

- TEMPERATURE CONTROL CONTRACTOR TO PROVIDE ALL LABOR, MATERIALS, PROGRAMING AND SUPERVISION THAT MAY BE REQUIRED FOR A COMPLETE AND FUNCTIONAL SYSTEM. TCC PROGRAMMING TO INCLUDE GRAPHICS FOR ALL NEW AND EXISTING SYSTEMS IN PROJECT AREA.
- TCC SHALL PROVIDE CONTROLS TO OPERATE NEW COOLING UNIT AS AN EXTENSION OF THE EXISTING FACILITY MANAGEMENT SYSTEM THROUGH EXISTING SPACE TEMPERATURE SENSOR COMPLETE AS REQUIRED.

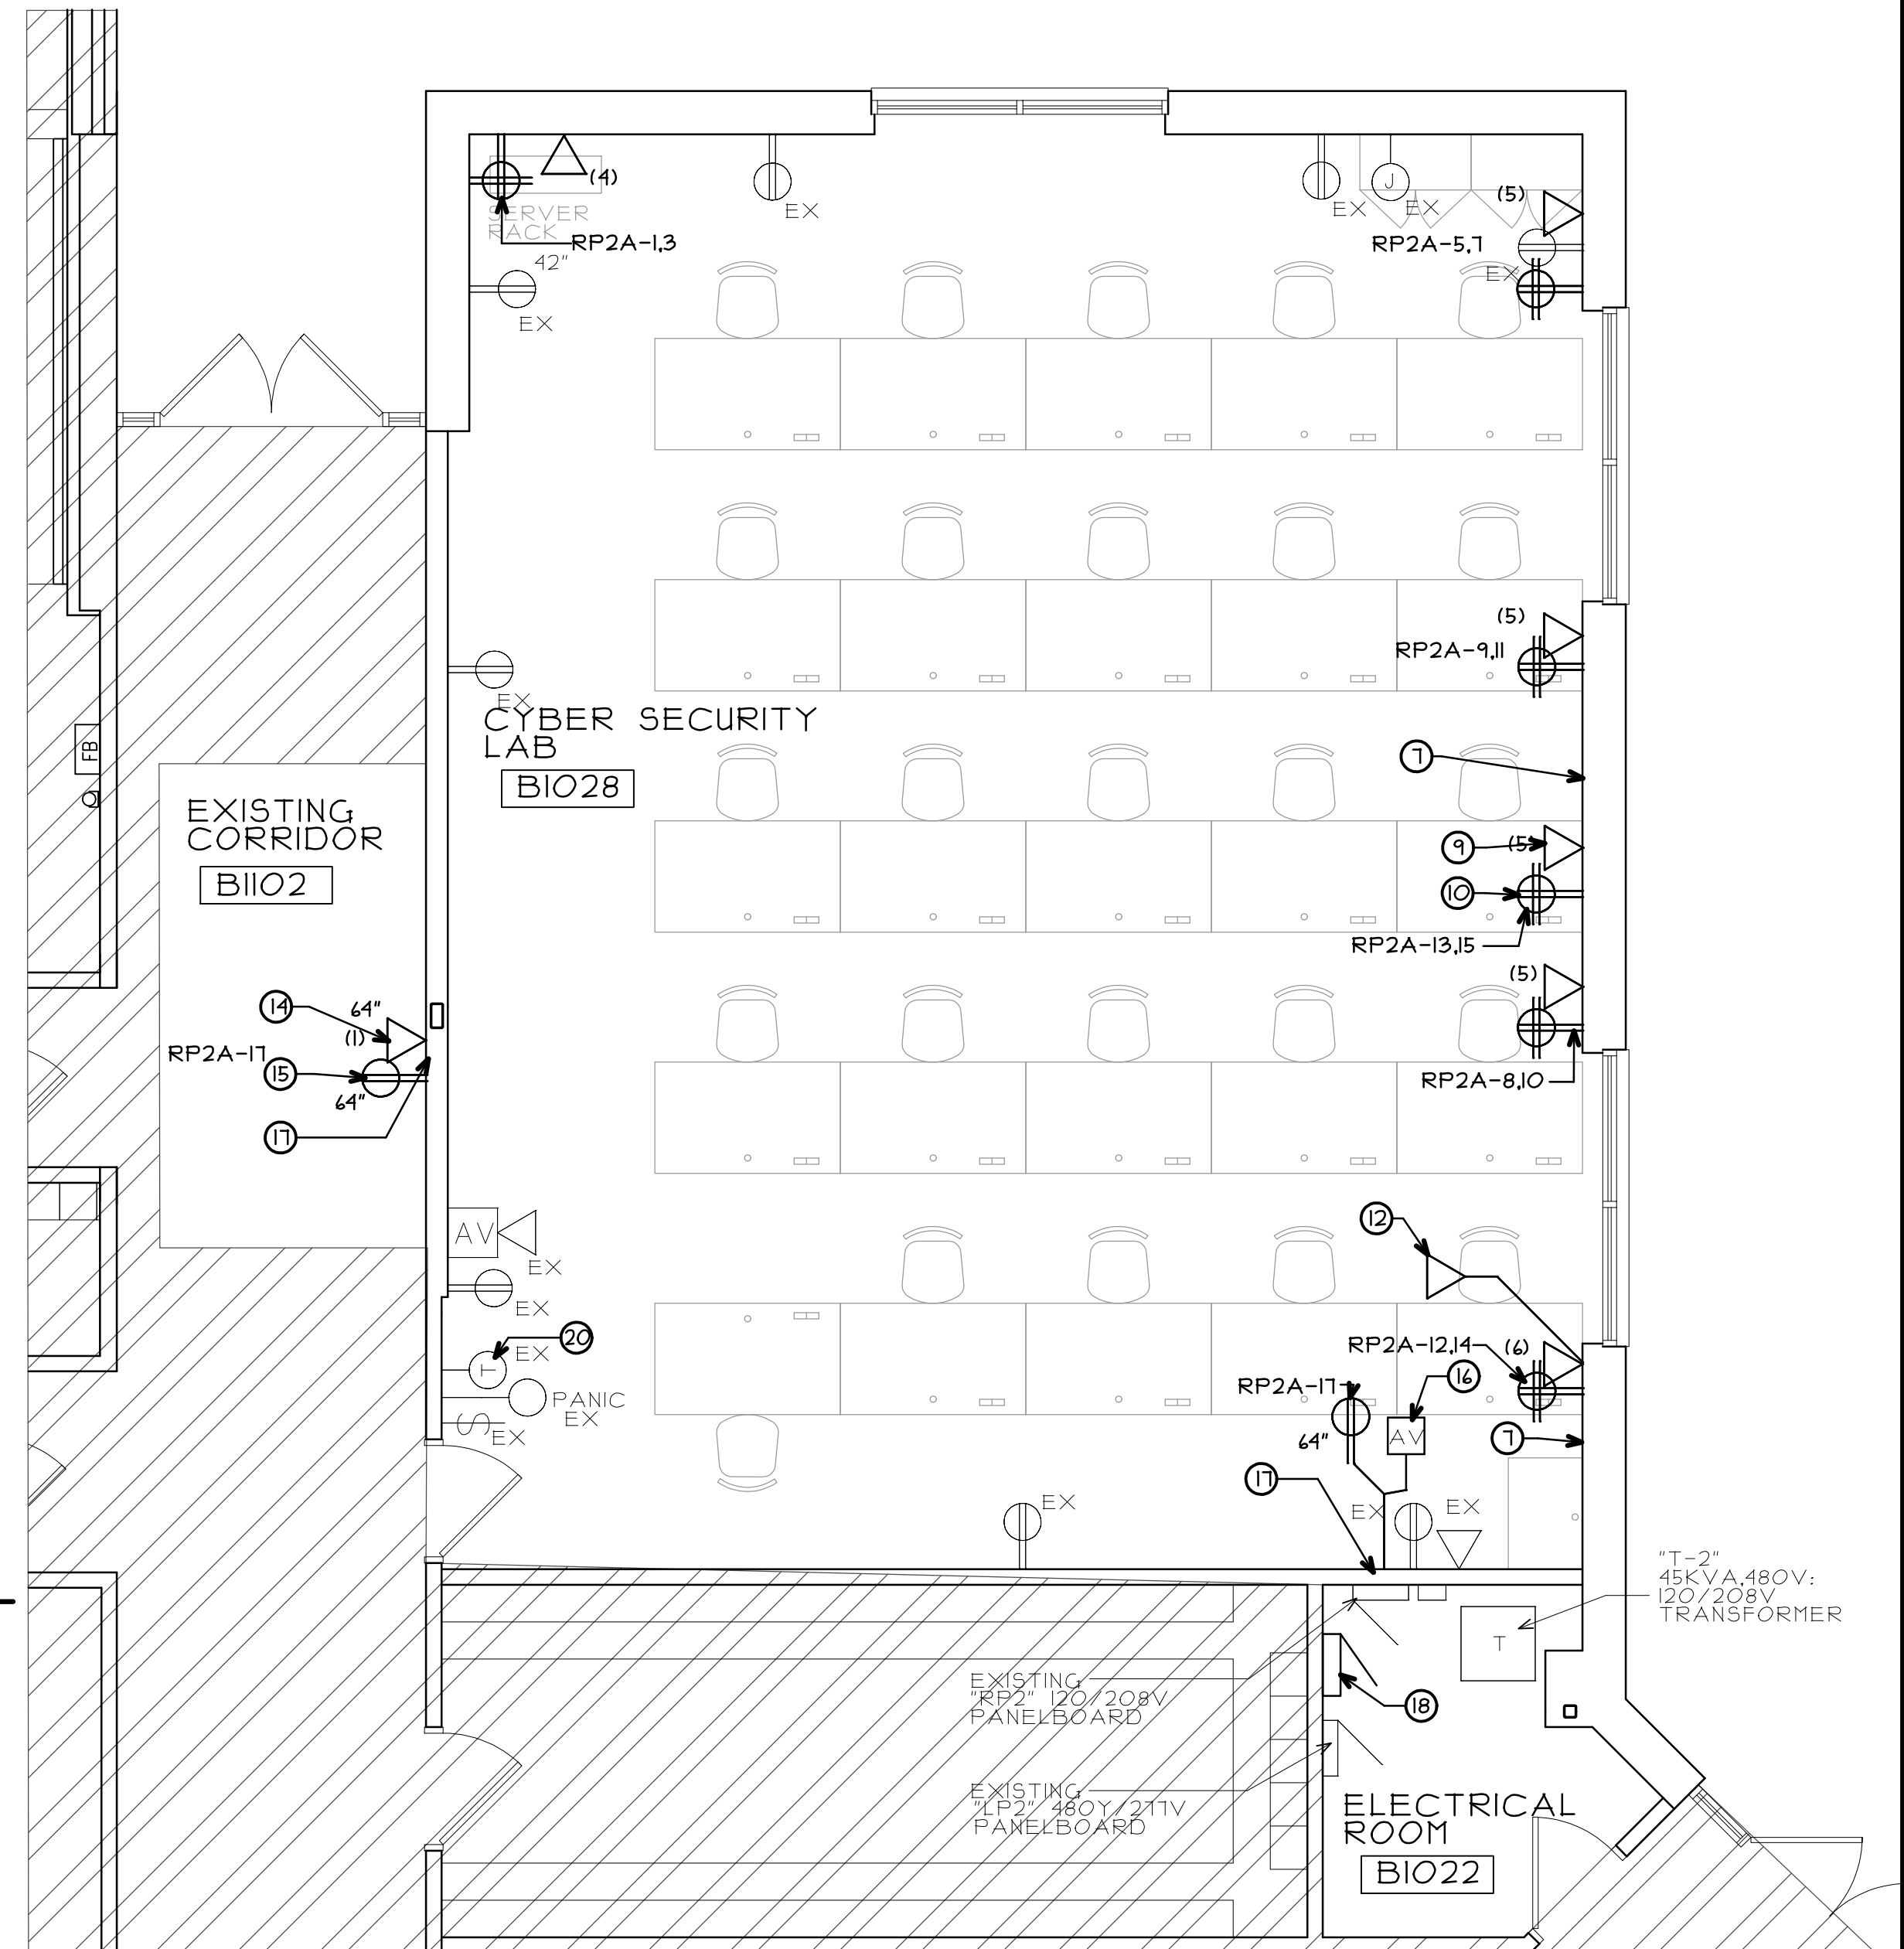

PARTIAL FIRST FLOOR PLAN
NORTH SCALE: 1/4" = 1'-0"

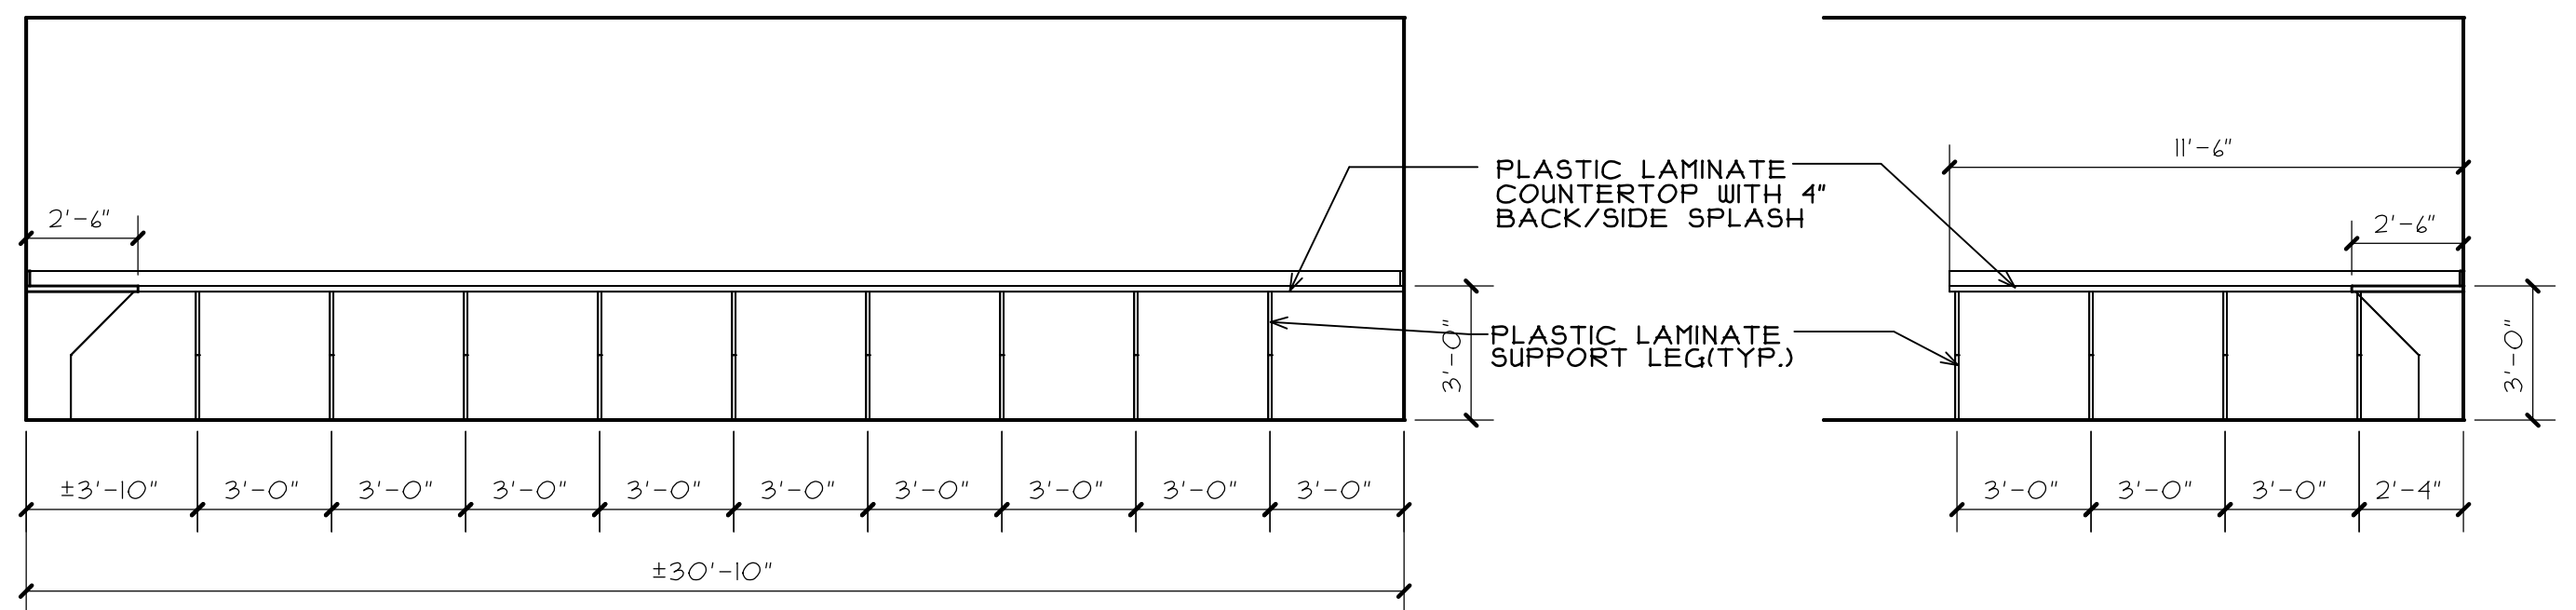

ELEVATION 1
NETWORKING SECURITY LAB
SCALE: 1/4" = 1'-0"

NOTE:
GENERAL CONTRACTOR TO PROVIDE A \$5,000 ALLOWANCE IN HIS/HER BID FOR UNFORESEEN/MISCELLANEOUS CONDITIONS. WHEN FIGURING THIS ALLOWANCE IN THE BID, THE CONTRACTOR IS TO INCLUDE ALL NECESSARY OVERHEAD AND PROFIT TO CARRY THIS DOLLAR VOLUME. THIS ALLOWANCE IS NOT FOR THE CONTRACTOR'S BENEFIT, AND IS ONLY AUTHORIZED TO CHARGE AGAINST THIS ALLOWANCE WHEN DIRECTED AND APPROVED BY JOLIET JUNIOR COLLEGE. THE CONTRACTOR WILL BE ALLOWED TO INVOICE FOR DIRECT MATERIAL AND RAW LABOR COSTS ONLY.

REGISTRATION

SEAL

stromsland + de young + prybys
ARCHITECTURE GROUP
20620 Burr Court - 102
Joliet, Illinois 60433
815-727-1311
L.N.: 184-000437
www.sdpagroup.com

NUMBER
SET

NETWORKING SECURITY AND CYBER SECURITY LABS
JOLIET JUNIOR COLLEGE - ROMEOVILLE CAMPUS
1125 W. ROMEO ROAD
ROMEOVILLE, ILLINOIS

DATE:
3/11/2022
REVISED:

PROJECT NO.
2111-01

SHEET NUMBER

A1


\\192.168.1137\CURRENT PROJECTS\JUC ROMEOVILLE CAMPUS- CISCO LAB RENOVATIONS\DRAWINGS\ARCH\A2AEC




PARTIAL FIRST FLOOR CEILING PLAN

NORTH SCALE: 1/4" = 1'-0"


REFLECTED CEILING PLAN LEGEND

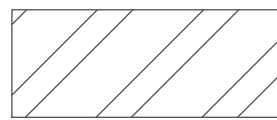


HATCH DENOTES AREAS NOT INCLUDED IN PROJECT SCOPE

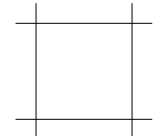

 
DENOTES EXISTING 2' X 2' SUSPENDED CEILING GRID SYSTEM AND ACOUSTICAL PANELS TO REMAIN (U.N.O.)



 
DENOTES EXISTING LAY-IN LIGHTING FIXTURE IN ACOUSTIC CEILING, SEE ELECTRICAL DRAWINGS




DENOTES NEW LED LAY-IN LIGHTING FIXTURE IN ACOUSTIC CEILING, (EPANL LED BY LITHONIA LIGHTING TO MATCH FACILITY STANDARD) CONNECT TO EXISTING ROOM SWITCHING.

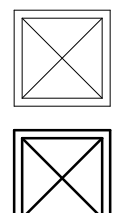

 DENOTES EXISTING LAY-IN SUPPLY DIFFUSER IN ACOUSTIC CEILING, SEE MECHANICAL NOTES



DENOTES SALVAGED/NEW LAY-IN SUPPLY DIFFUSER IN ACOUSTIC CEILING, SEE MECHANICAL NOTES

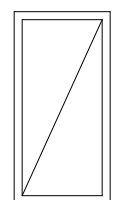

DENOTES EXISTING LAY-IN RETURN REGISTER IN ACOUSTIC CEILING, SEE MECHANICAL NOTES



DENOTES EXISTING SPRINKLER HEAD LOCATION IN CEILING/SOFFIT TO REMAIN.



DENOTES EXISTING OCCUPANCY SENSOR TO REMAIN



DENOTES EXISTING WIFI ANTENNA TO REMAIN



DENOTES NEW WIFI ANTENNA TO BE FURNISHED AND INSTALLED BY OWNERS STAFF, CONTRACTOR TO EXTEND DATA CABLING TO THIS LOCATION.



DENOTES EXISTING AUDIO SPEAKER TO REMAIN



DENOTES NEW DIMMER SWITCH. (LEVITRON IP10-LF IS FACILITY STANDARD) BRUSHED STAINLESS STEEL COVERPLATE.



DIM.

CEILING PLAN GENERAL NOTES

- PATCH & REPAIR ALL EXISTING GYPSUM BOARD SURFACES TO "LIKE NEW" CONDITION PRIOR TO INSTALLING NEW FINISHES.
- CEILING GRID AND LAY-IN PANEL TYPES ARE EXISTING TO REMAIN. (U.N.O.)
- COORDINATE WITH AND ALLOW OWNER'S SEPARATE VENDORS ACCESS TO CEILING INTERSTITIAL SPACES FOR INSTALLATION OF WIRING AND EQUIPMENT PRIOR TO INSTALLING LAY IN CEILING PANELS.
- EXISTING DAMAGED ACOUSTIC CEILING PANELS SHALL BE CLEANED OR REPLACED WITH NEW MATCHING PANELS FROM OWNERS ATTIC STOCK (V.I.F.).
- ALL GYPSUM BOARD SOFFITS, HEADERS, ETC. WITHIN THE WORK AREA ARE TO RECEIVE A NEW PAINT FINISH.


CEILING PLAN KEY NOTES

- CAP OFF BOTTOM OF EXISTING PORTION OF GYPSUM BOARD PARTITION TO REMAIN TO PROVIDE NEW GYPSUM BOARD HEADER, SEE DETAIL 1 ON SHEET A2.
- PATCH CEILING PANELS AND GRID BACK INTO CEILING A.C. CASSETTE UNIT USING SALVAGED GRID AND PANELS. (V.I.F.)
- NEW PROJECTOR LOCATION, (COORDINATE WITH OWNER PROVIDED EQUIPMENT) EXTEND EXISTING POWER AND DATA CABLING TO NEW LOCATION, NEW DROP IN PROJECTOR PLATE TO BE FURNISHED AND INSTALLED BY OWNER, CONTRACTOR TO PROVIDE ADDITIONAL HANG WIRES FOR SUPPORT AT LOCATION OF NEW PROJECTOR. (V.I.F.)
- PROVIDE NEW CEILING MOUNTED A.C. CASSETTE, SEE SHEET A0 FOR MORE INFORMATION AND DETAIL 2 ON SHEET A2 FOR MOUNTING INFORMATION. (COORDINATE LOCATION IN FIELD)
- EXISTING QUAD OUTLET FOR PROJECTOR TO BE RELOCATED IF NECESSARY TO INSTALL NEW A.C. CEILING CASSETTE. (V.I.F.)





PARTIAL FIRST FLOOR CEILING PLAN

SCALE: 1/4" = 1'-0"

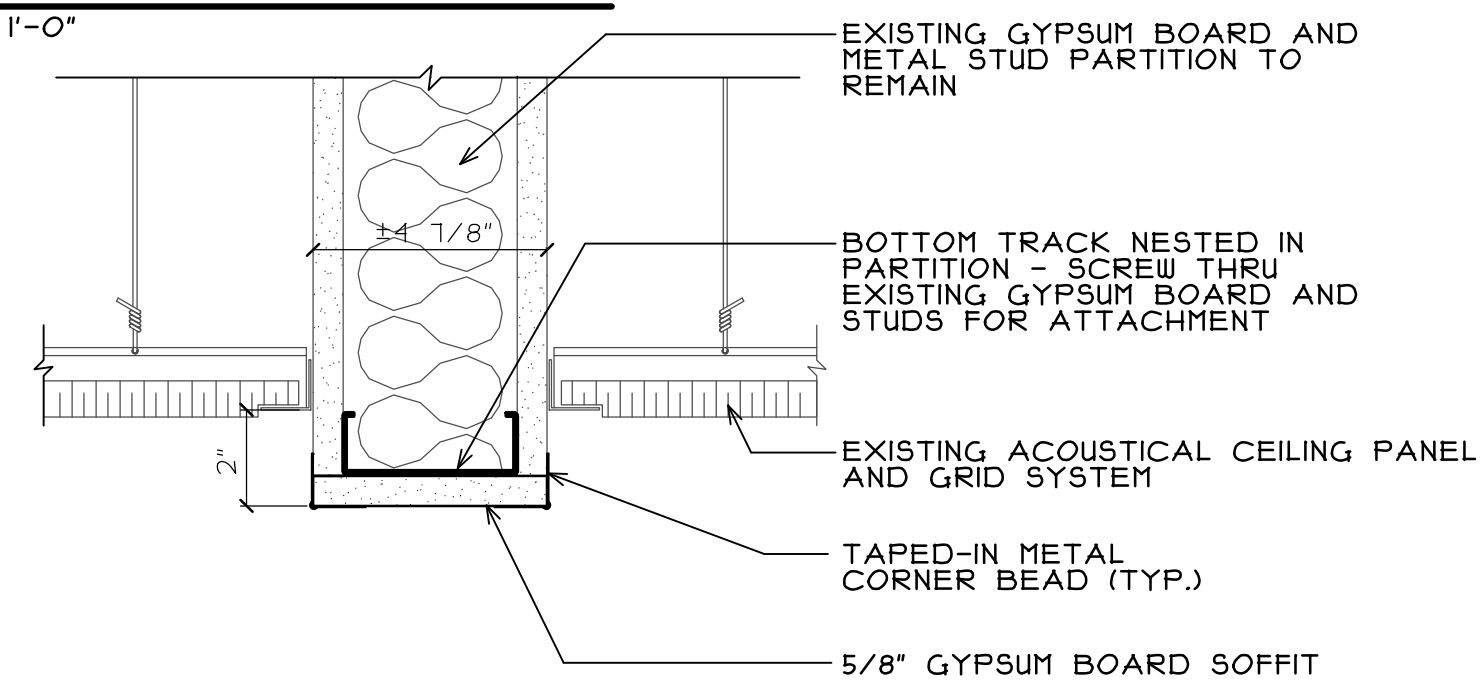

GYPSUM BOARD HEADER

 SCALE: 3" = 1'-0"

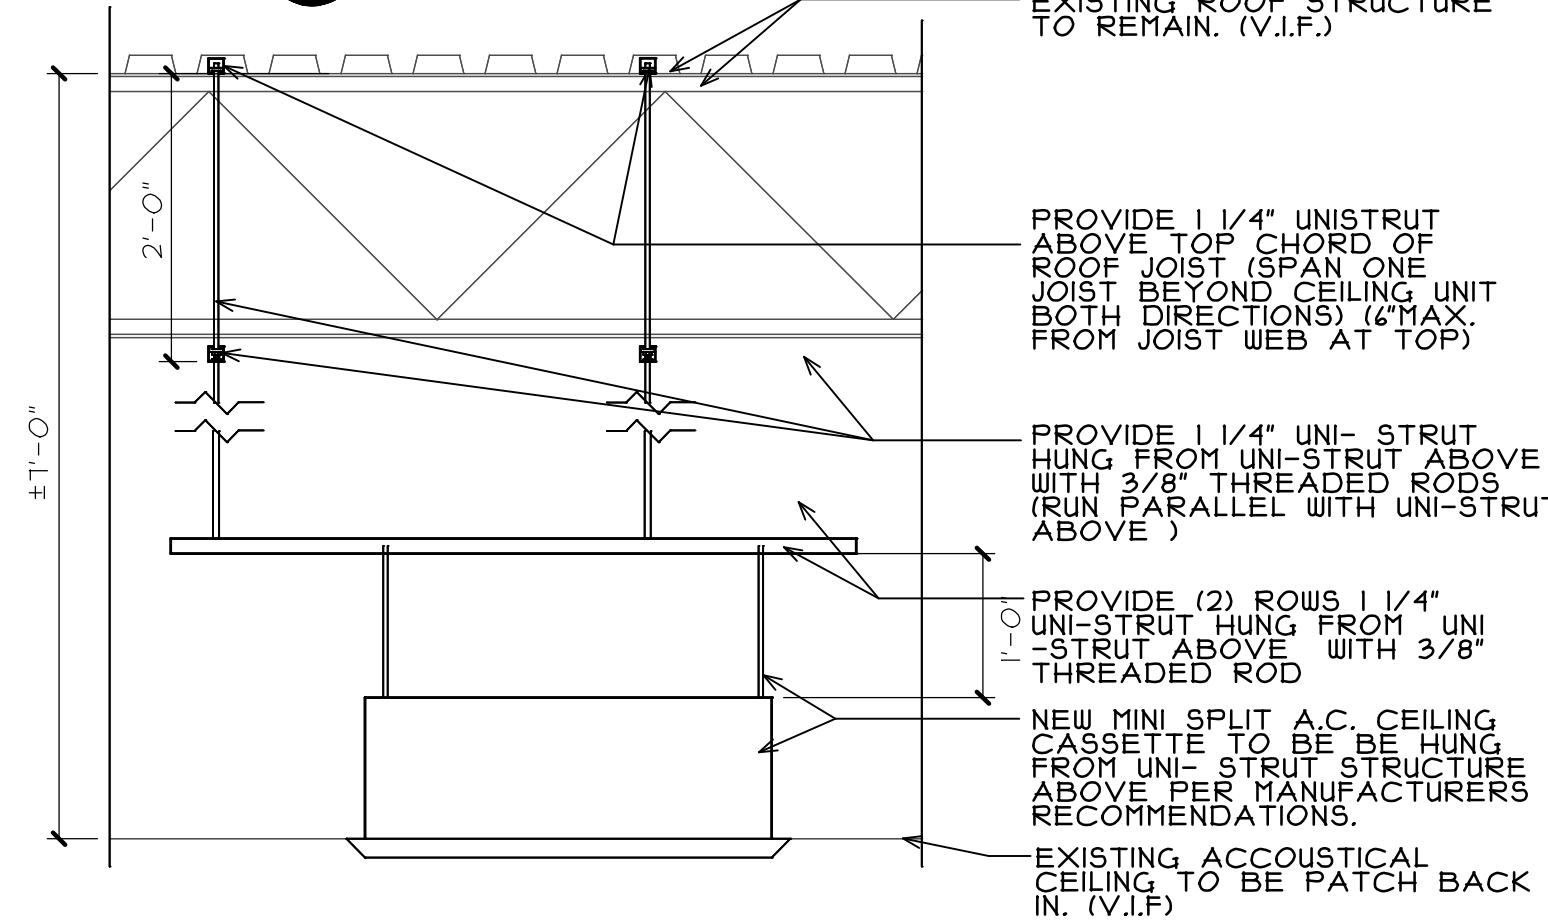

DETAIL AT AC CASSETTE MOUNTING

SCALE: 3/4" = 1'-0"

COPYRIGHT 2022 © S D P ARCHITECTURE GROUP, INC.

REGISTRATION

SEAL

stromsland + de young + prybys

ARCHITECTURE GROUP

20620 Burl Court - 102
Joliet, Illinois 60433

www.sdpagroup.com

815-727-1311

L. N. : 184-000437

NUMBER

SET

NETWORKING SECURITY AND CYBER SECURITY LABS
JOLIET JUNIOR COLLEGE- ROMEOVILLE CAMPUS
1125 W. ROMEO ROAD
ROMEOVILLE, ILLINOIS

DATE: 3/11/2022
REVISED:

PROJECT NO.
2111-01

SHEET NUMBER

A2

OF 3 SHEETS